



An aerial photograph of a school campus. The central feature is a large, dark-roofed building with a complex, multi-winged layout. To the left of the building is a red-surfaced basketball court and a smaller parking area. To the right is a large, paved parking lot filled with numerous cars. Further back, there is a large, open grassy field, possibly a soccer field or baseball field, surrounded by trees. The campus is bordered by a road on the left and a residential neighborhood with houses and trees on the right. A road with a median runs horizontally across the bottom of the image, with a line of cars parked along its edge.

128 Center Street
Pembroke, MA
Assessors Map D9 Lot 1

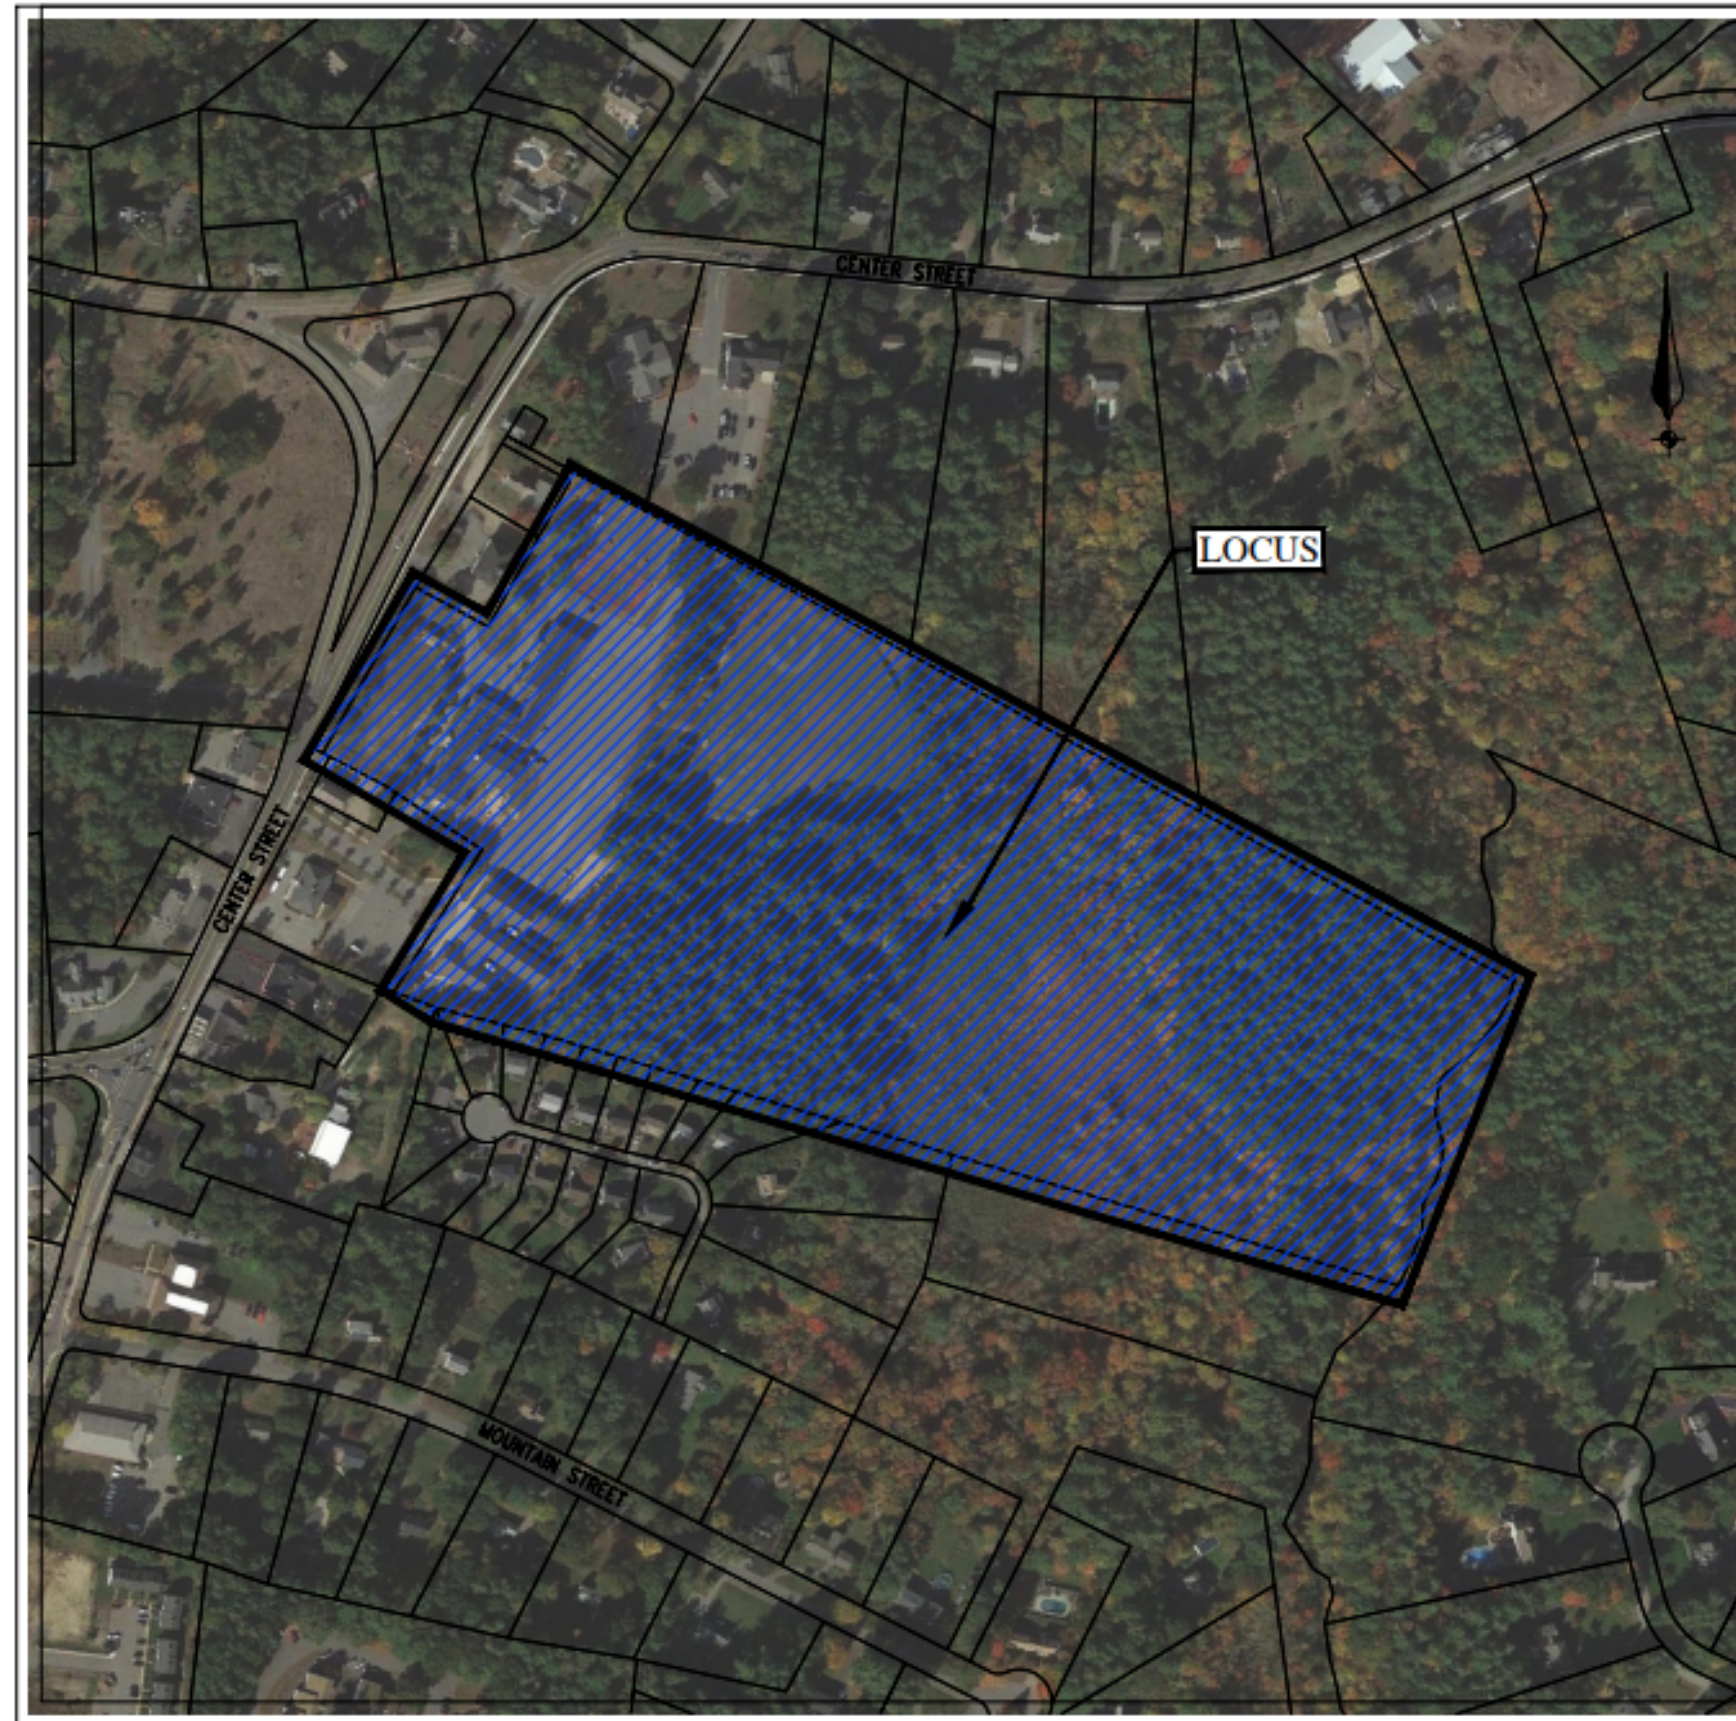


— VICINITY MAP —
SCALE: 1"=200'

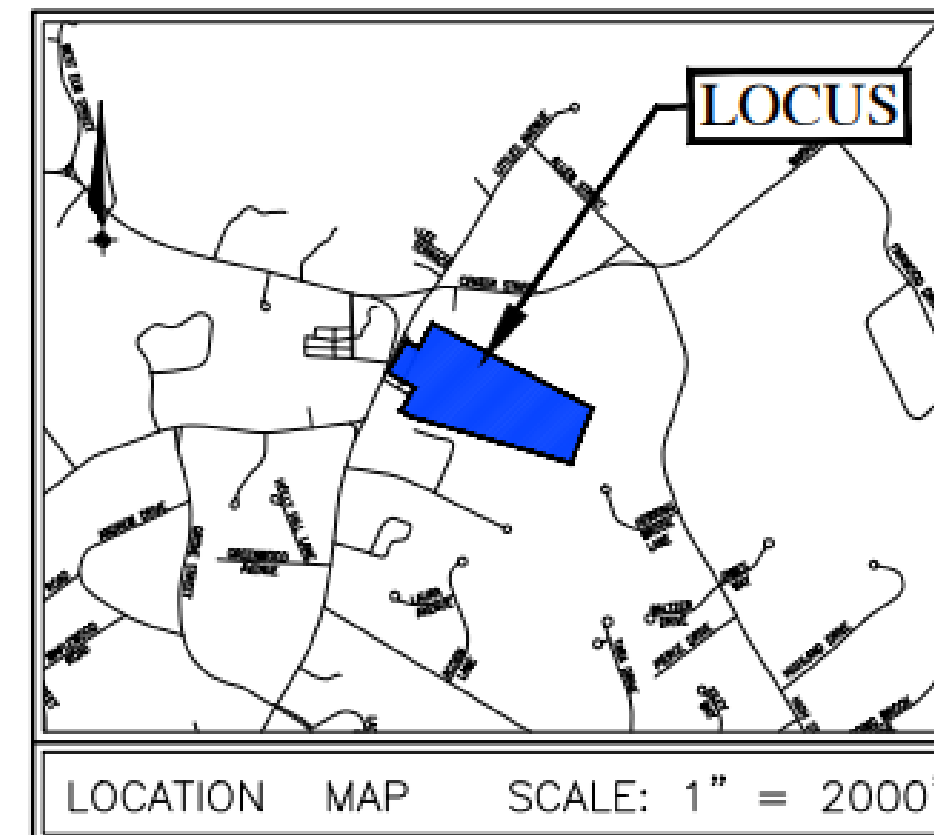

- | | | | |
|-------|-----------------------|-------|-------------------------------------|
| A-000 | Cover Sheet | L100 | Landscape Notes |
| | | L101 | Landscape Materials Plan |
| C101 | Vicinity & Index | L102 | Landscape Materials Plan |
| C201 | Existing Conditions | L103 | Planting Plan |
| C202 | Existing Conditions | L104 | Planting Plan |
| C203 | Existing Conditions | LD1 | Landscape Details |
| C301 | Erosions Control/Demo | LD2 | Landscape Details |
| C302 | Erosions Control/Demo | | |
| C401 | Layout & Zoning | SLP1 | Site Lighting Plan Photometric |
| C402 | Layout & Zoning | | |
| C501 | Grading & Utilities | A-101 | First Floor Plan |
| C502 | Grading & Utilities | A-102 | Second Floor Plan |
| C601 | Site Details | A-103 | Roof Plan |
| C602 | Site Details | A-200 | Exterior Elevations - East & West |
| C603 | Site Details | A-201 | Exterior Elevations - North & South |
| C604 | Site Details | | |

Kyle Zick Landscape Architecture
Boston, MA

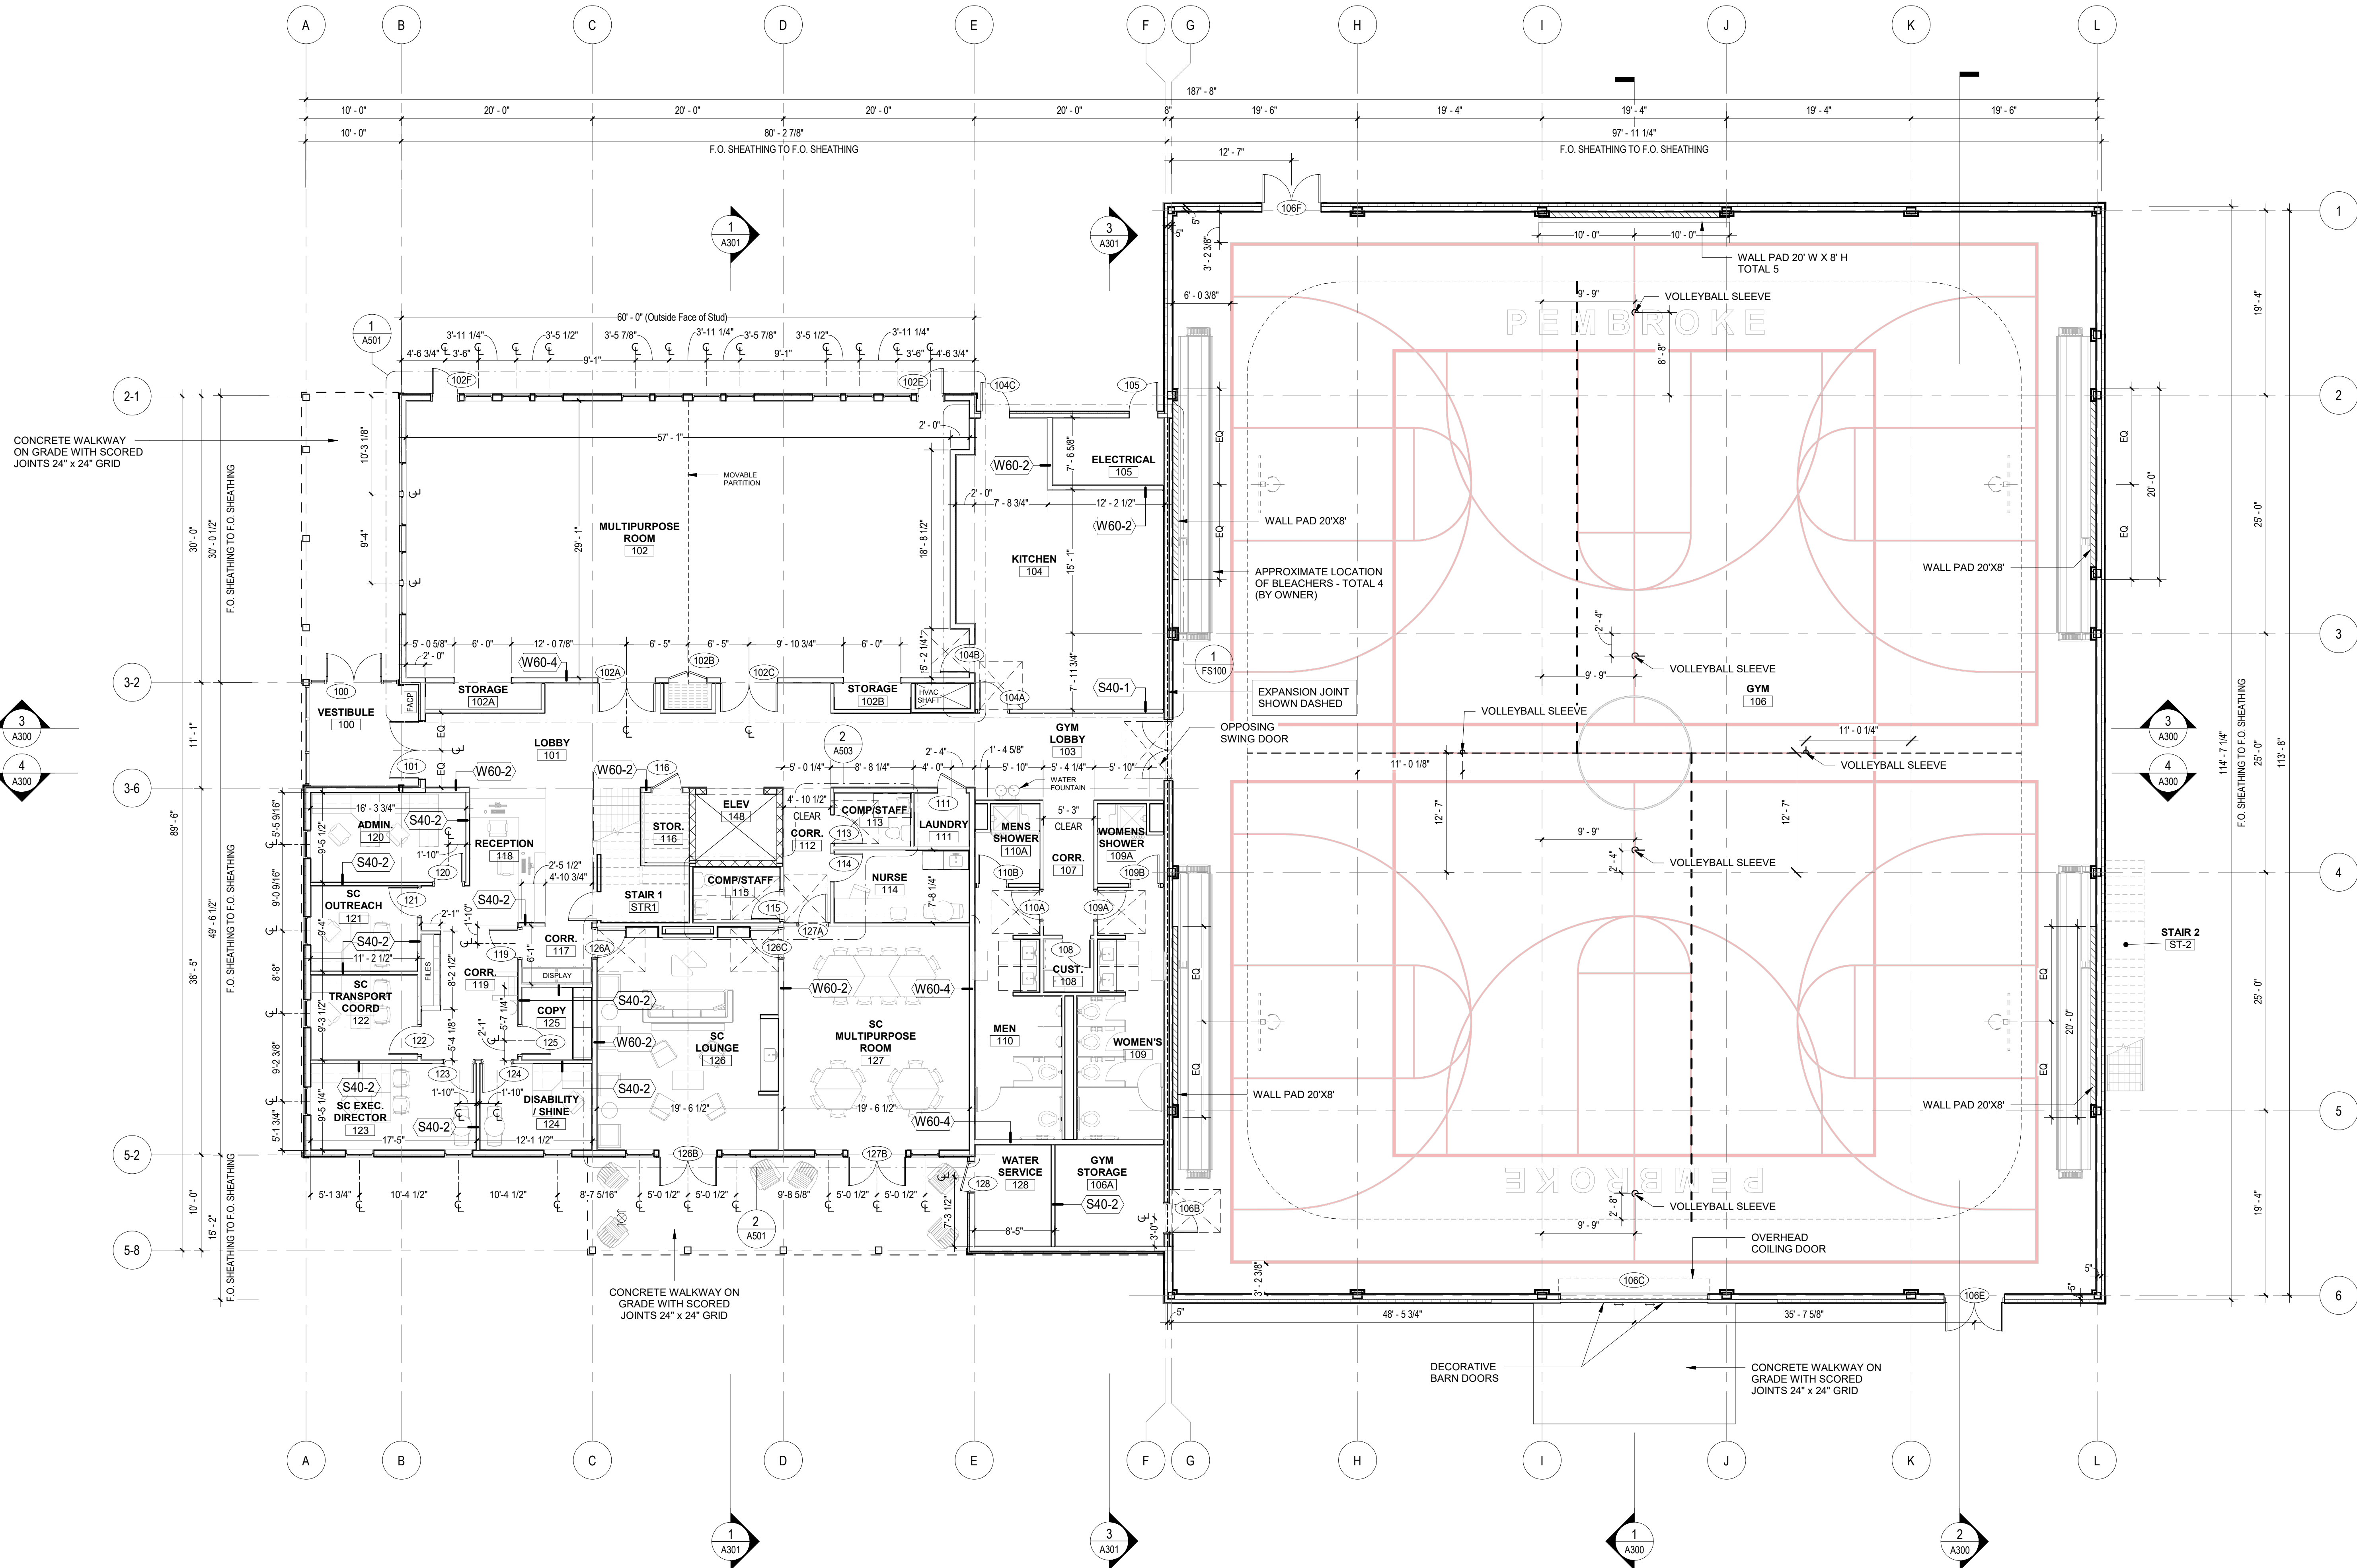

ARCHITECT

bh+a

Bargmann Hendrie + Archetype, Inc.
9 Channel Center Street, Suite 300
Boston, MA 02210
(617) 350 0450

PROJECT NAME

Pembroke Community Center
128 Center Street
Pembroke, MA, 02359

CLIENT

Town of Pembroke MA
100 Center Street
Pembroke, MA, 02359

PROJECT TEAM

Civil Engineer
Merrill Engineers & Land Surveyors
427 Columbia Road
Hanover, MA, 02339
(781) 826-9200
Landscape Architect
Kyle Zick Landscape Architecture, Inc.
36 Bromfield Street, Suite 202
Boston, MA, 02108
(617) 451-1018
Structural Engineer
Foley Buhl Roberts & Associates, Inc.
2150 Washington Street
Newton, MA, 02462
(617) 527-9600
MEP/FP Engineer
Allied Consulting Engineering Services
235 Littleton Road, Suite 5
Westford, MA, 01886
(978) 443-7888
Geotechnical Engineer
McArdle Cannon Associates, Inc.
300 Oak Street, Suite 460
Pembroke, MA 02359
(781) 826-0040
Elevator Consultant
B Squared Engineering
169 Mill Brook Road
Stamford, CT, 06902
(203) 989-9029
Food Service Consultant
Crabtree McGrath Associates
161 West Main Street
Georgetown, MA 01833
(978) 352-8500

REVISIONS

DRAWING TITLE

First Floor Plan

DRAWING INFORMATION

May 6, 2022
DATE OF ISSUE

Site Plan Review
DESCRIPTION

1/8" = 1'-0"
SCALE

3403.00
PROJECT #

Author
DRAWN BY


Pembroke
FILE NAME


DRAWING NUMBER

A-101

Copyright BHA, Inc.

V.2.1

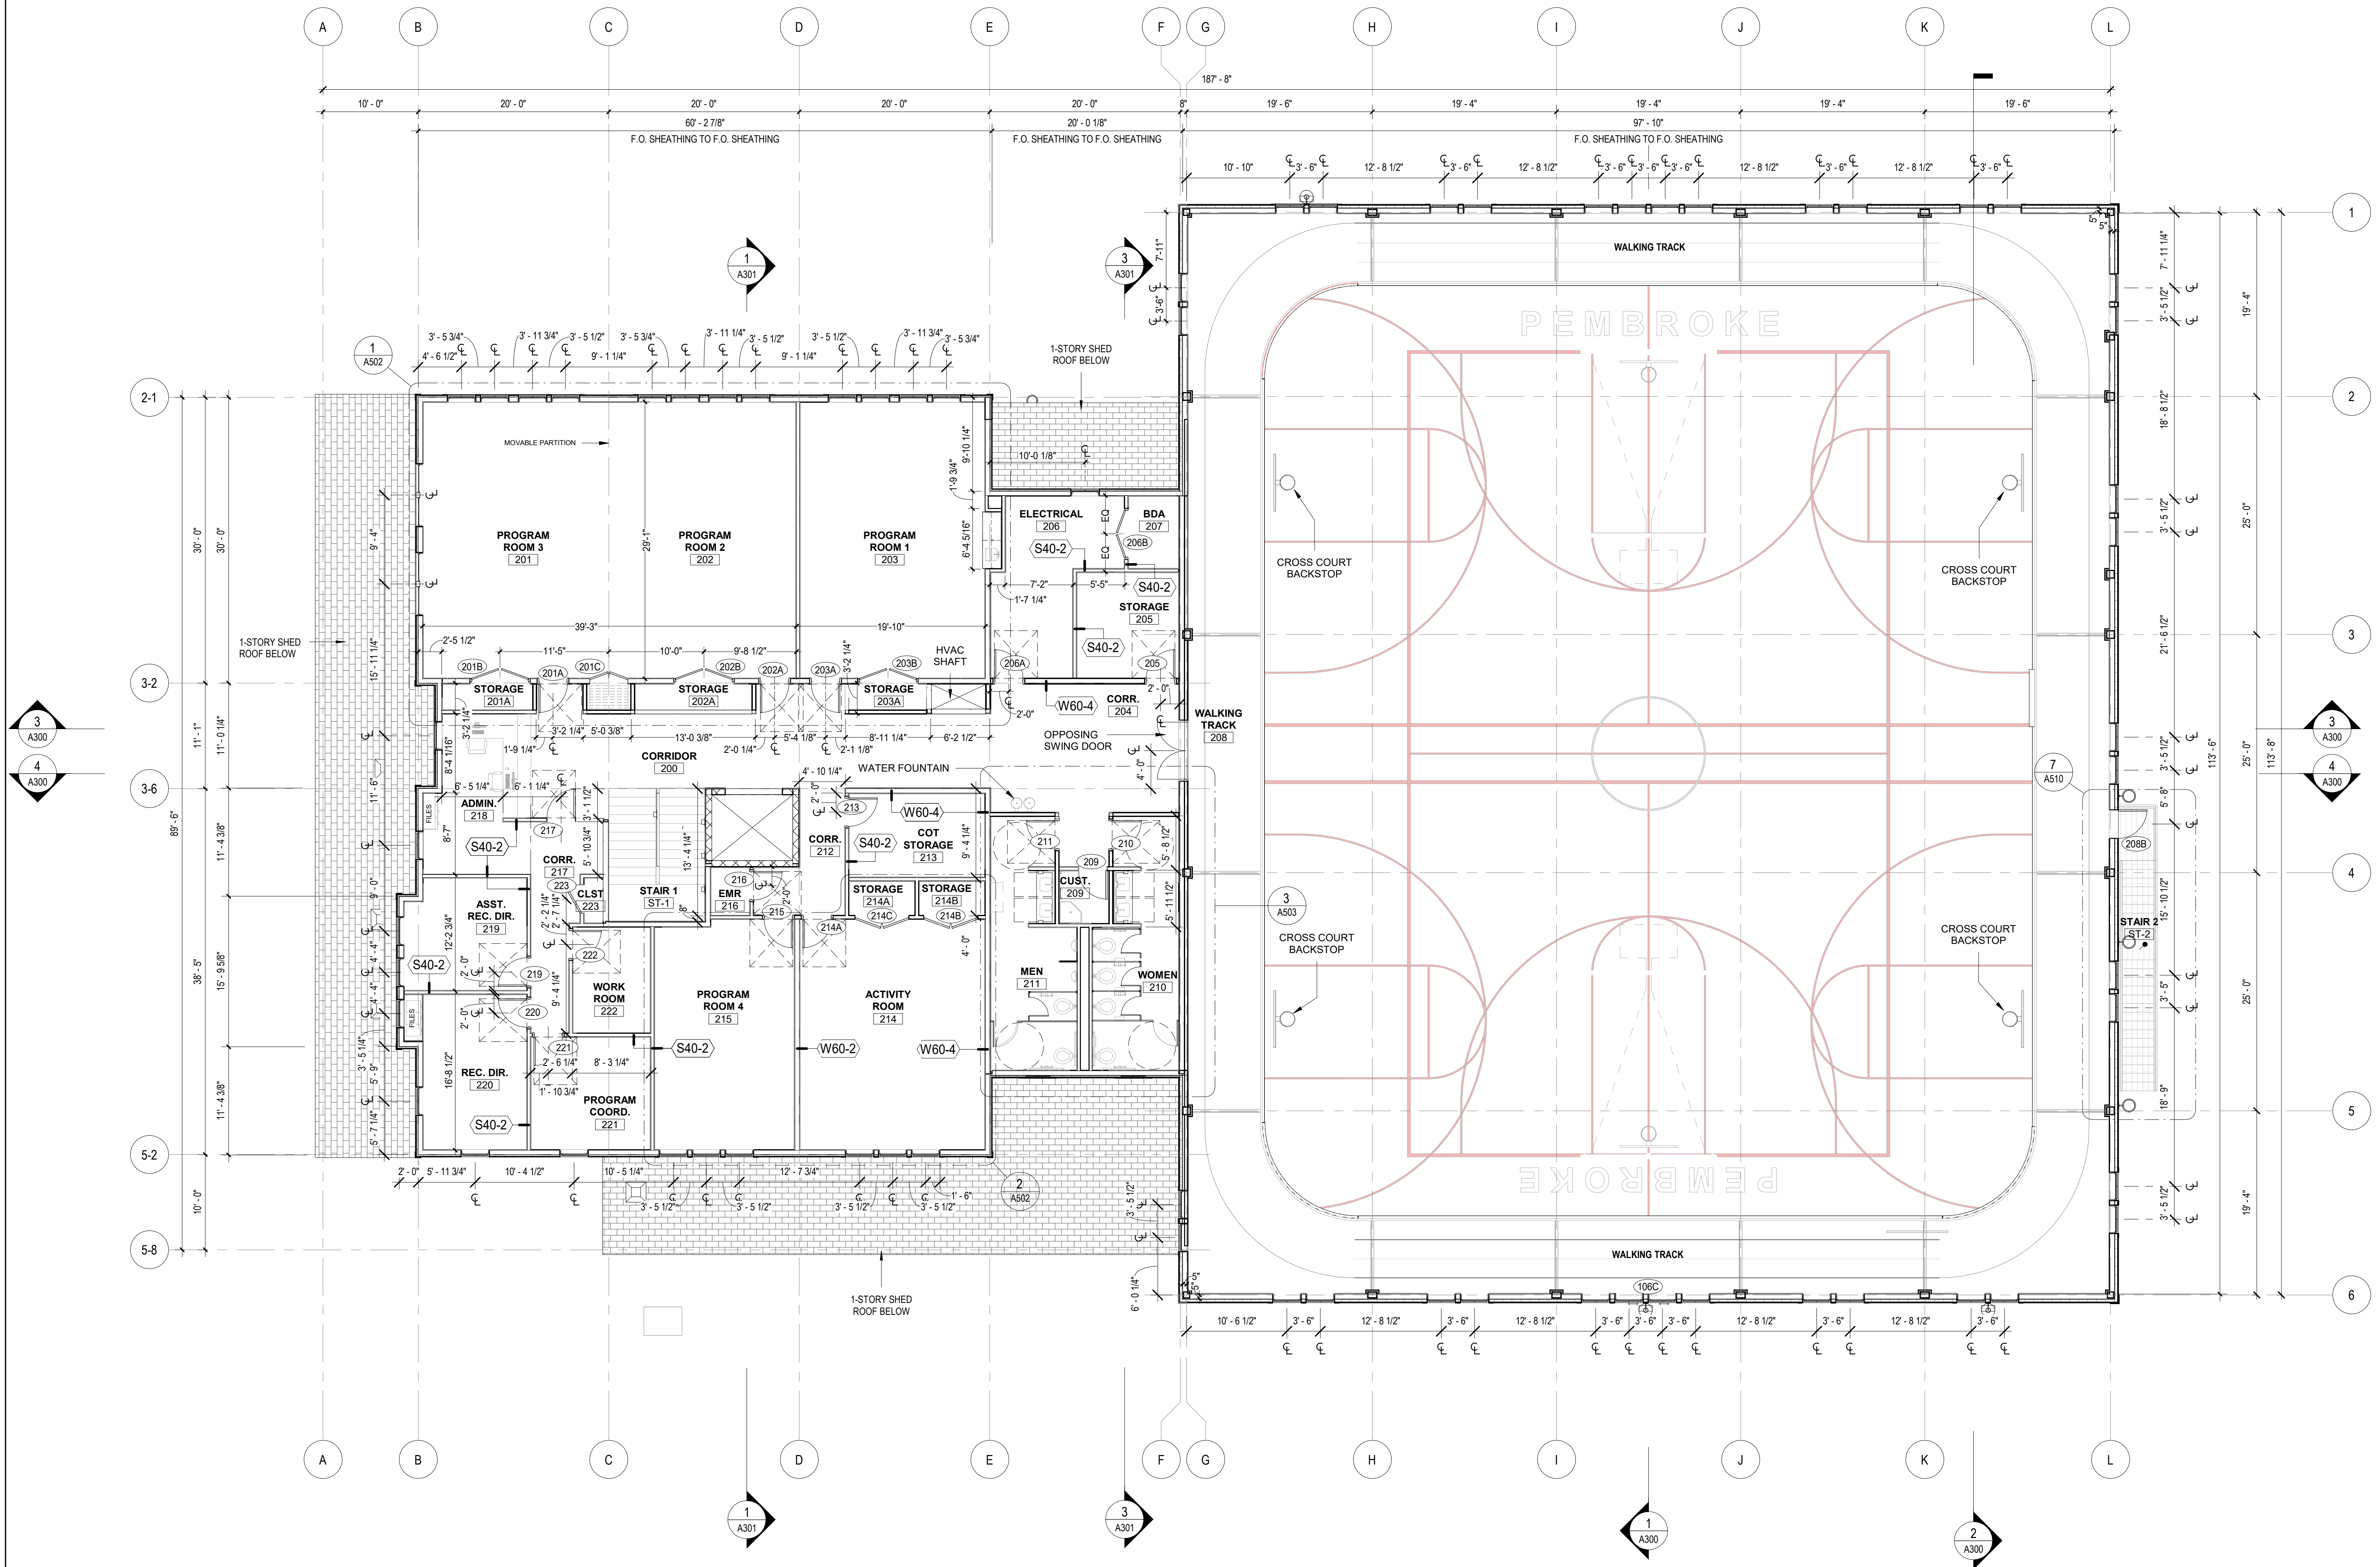

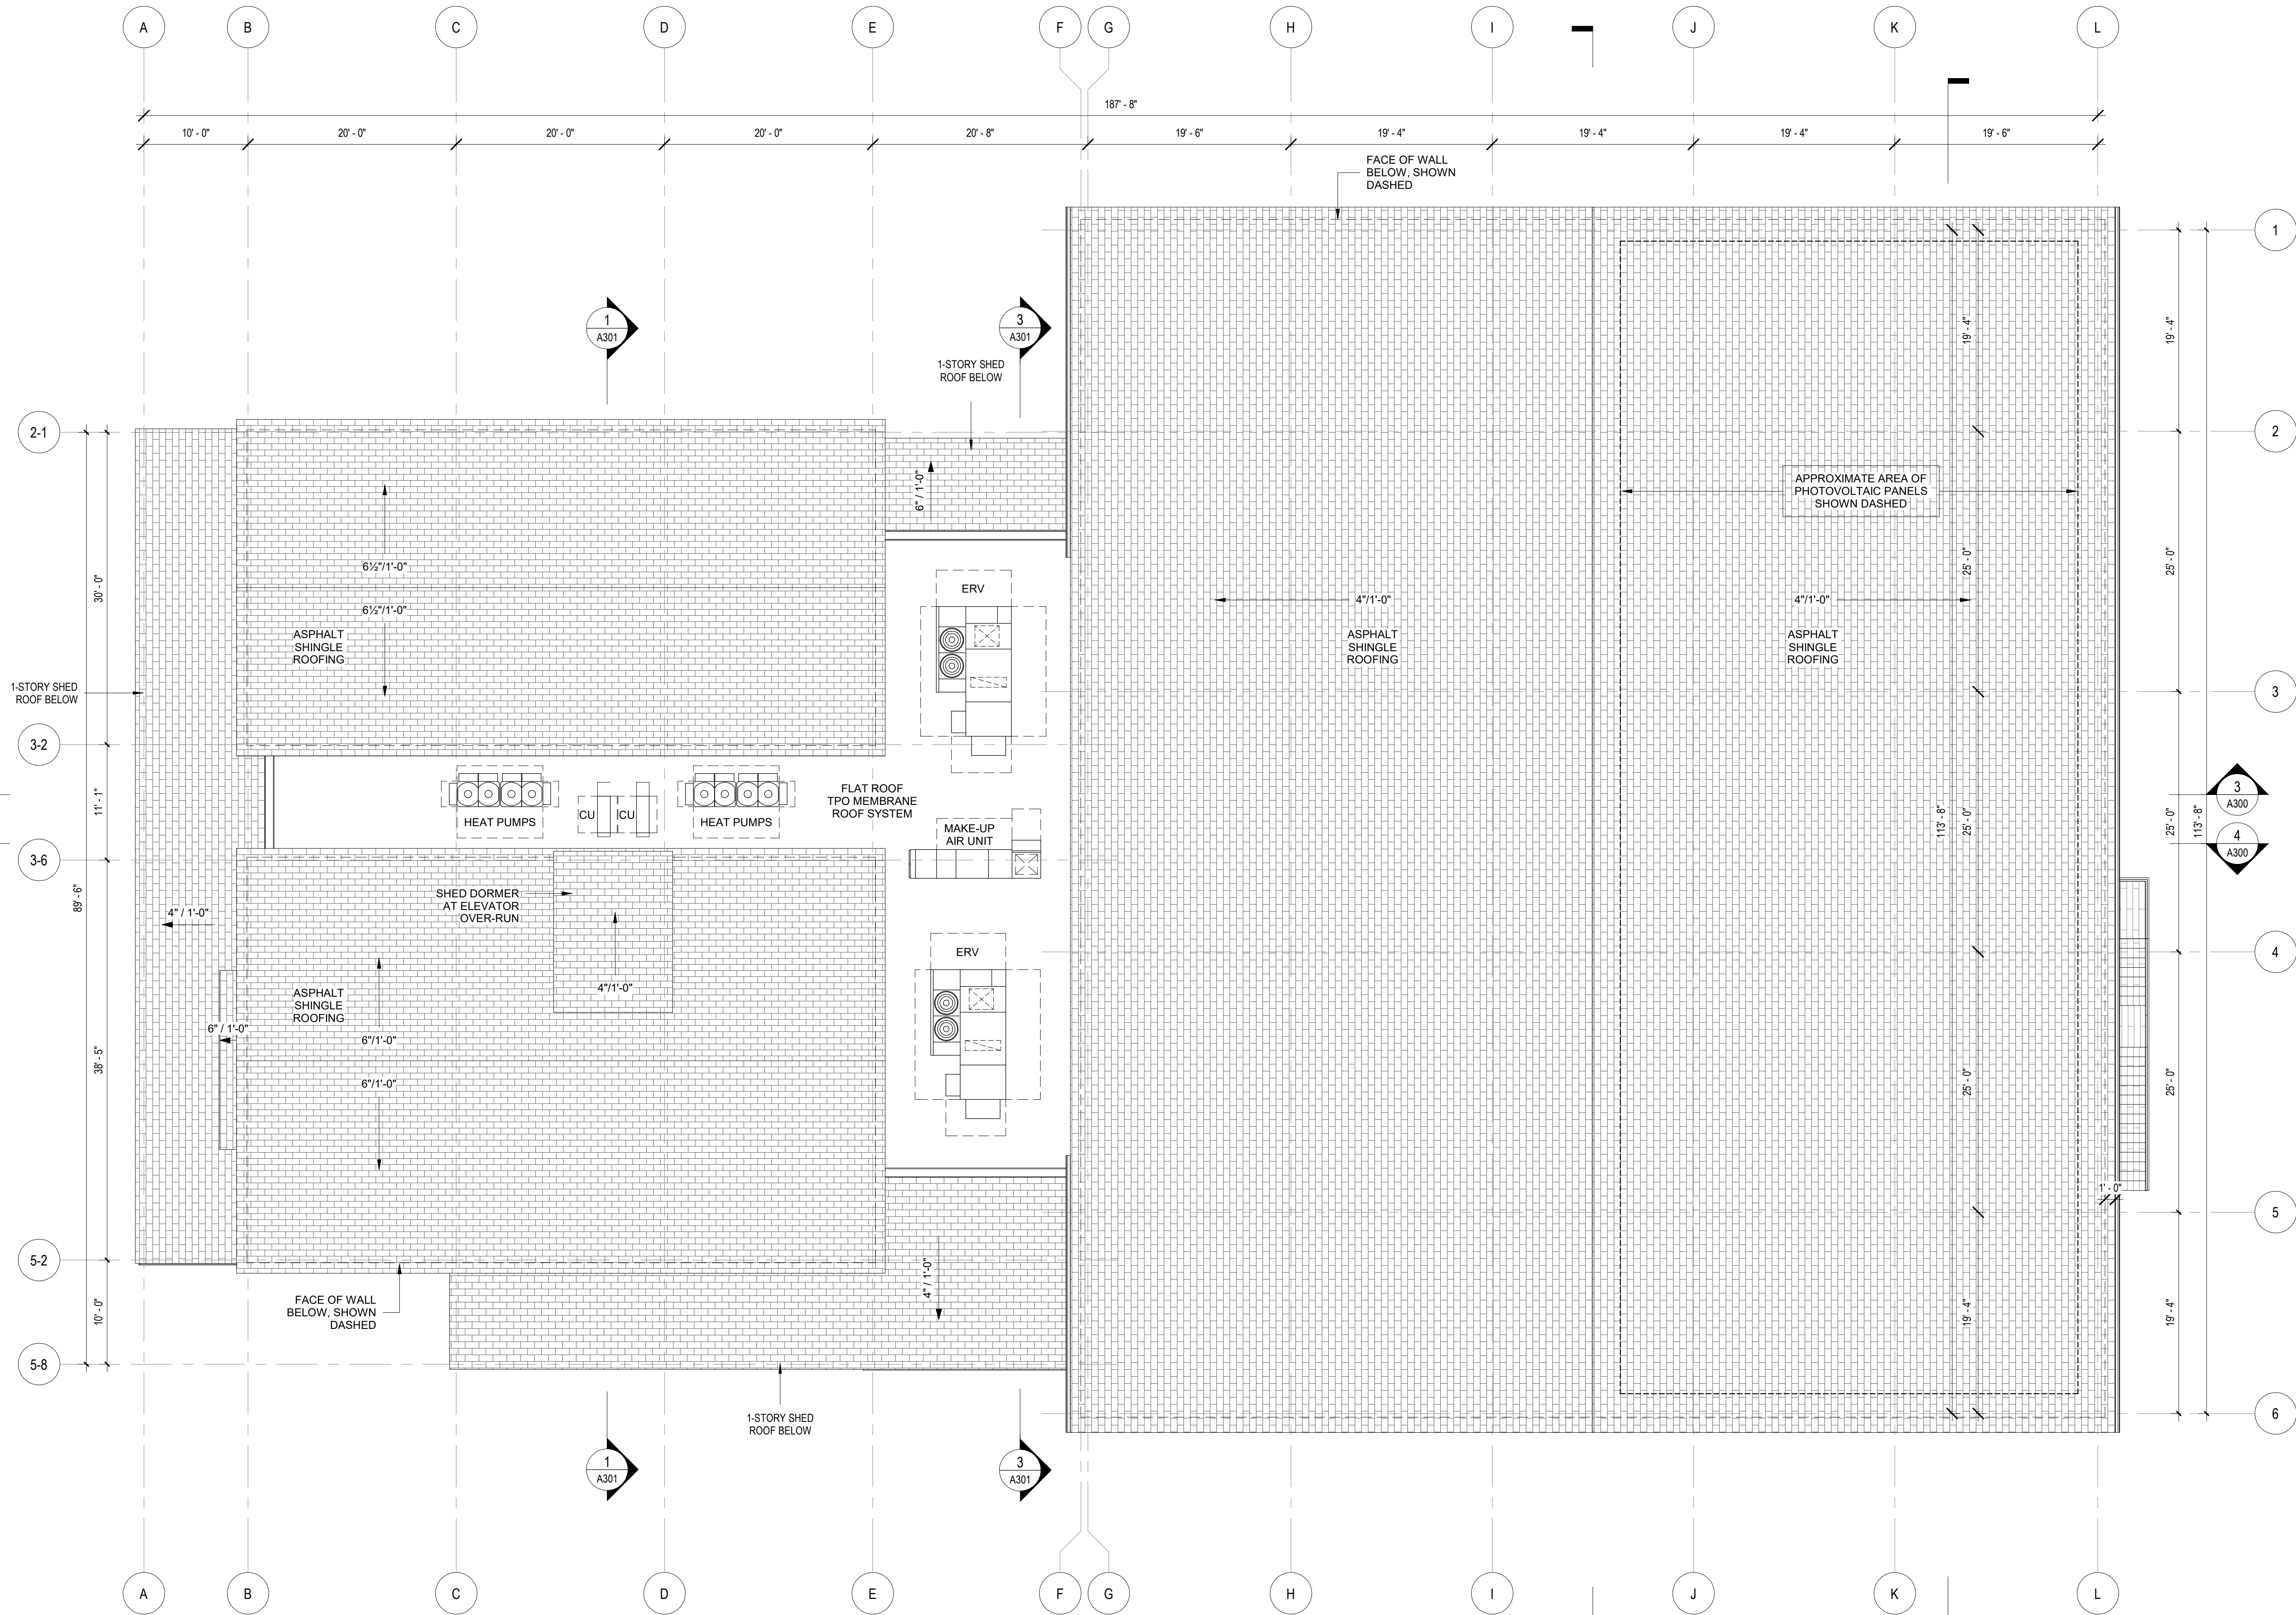

ARCHITECT

bh+a

Bargmann Hendrie + Archetype, Inc.
9 Channel Center Street, Suite 300
Boston, MA 02210
(617) 350 0450

PROJECT NAME

Pembroke Community Center
128 Center Street
Pembroke, MA, 02359

CLIENT

Town of Pembroke MA
100 Center Street
Pembroke, MA, 02359

PROJECT TEAM

Civil Engineer
Merrill Engineers & Land Surveyors
427 Columbia Road
Hanover, MA, 02339
(781) 826-9200

Landscape Architect
Kyle Zick Landscape Architecture, Inc.
36 Bromfield Street, Suite 202
Boston, MA, 02108
(617) 451-1018

Structural Engineer
Foley Buhl Roberts & Associates, Inc.
2150 Washington Street
Newton, MA, 02462
(617) 527-9600

MEP/FP Engineer
Allied Consulting Engineering Services
235 Littleton Road, Suite 5
Westford, MA, 01886
(978) 443-7888

Geotechnical Engineer
McArdle Cannon Associates, Inc.
300 Oak Street, Suite 460
Pembroke, MA 02359
(781) 826-0040

Elevator Consultant
B Squared Engineering
169 Mill Brook Road
Stamford, CT, 06902
(203) 989-9029

Pool Service Consultant
Crabtree McGrath Associates
161 West Main Street
Georgetown, MA 01833
(978) 352-8500

REVISIONS

DRAWING TITLE

Roof Plan

DRAWING INFORMATION

May 6, 2022
DATE OF ISSUE

Site Plan Review
DESCRIPTION

1/8" = 1'-0"
SCALE

3403_00
PROJECT #

Author
DRAWN BY


Pembroke
FILE NAME

DRAWING NUMBER



A-103

Copyright BH+A, Inc.


V.2.1

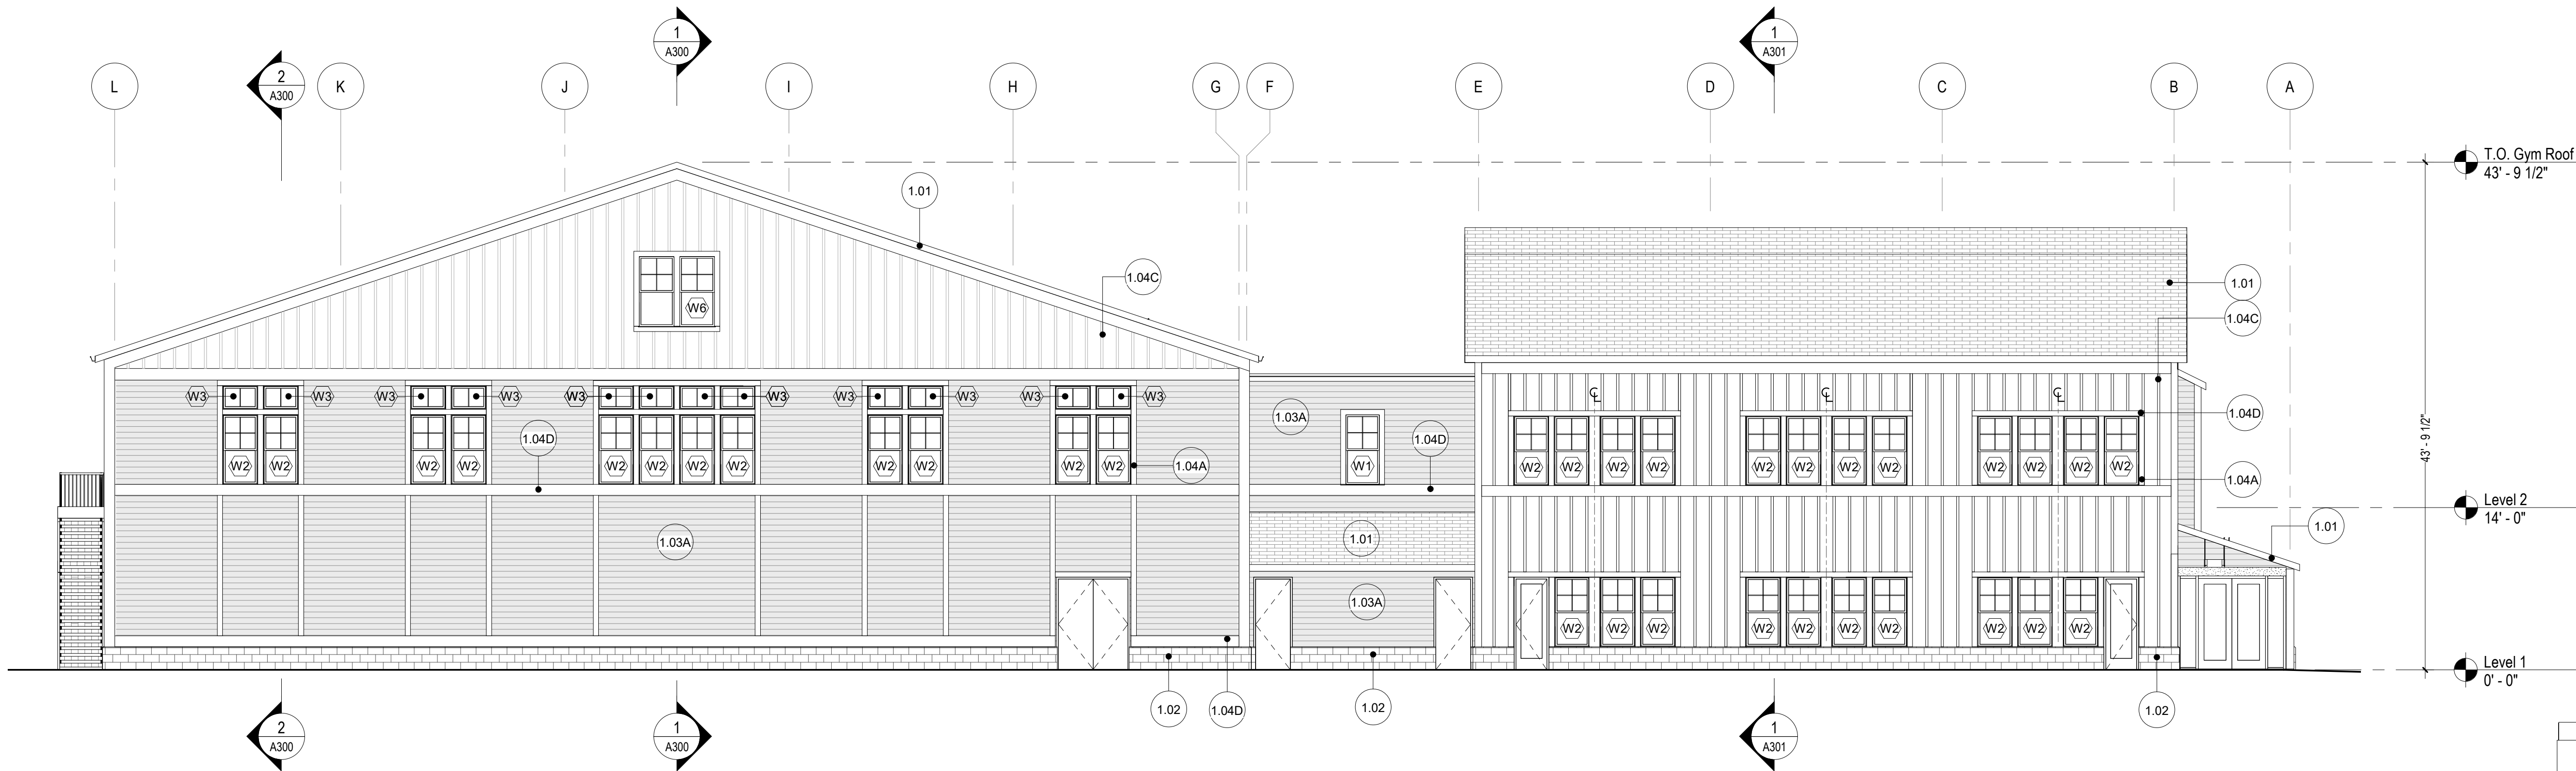


ELEVATION NOTES	
Key Value	Keynote Text
1.01	ASPHALT SHINGLE ROOFING
1.02	MASONRY - GROUND FACE BLOCK - 4X8X16
1.03A	SIDING TYPE 1 - FIBER CEMENT LAP SIDING, 4" EXPOSURE
1.04A	TRIM TYPE 1 - VERTICAL TYPICAL CORNER & DOOR/WINDOW
1.04C	TRIM TYPE 3 - VERTICAL BATTEN (THIN)
1.04D	TRIM TYPE 4 - HORIZONTAL

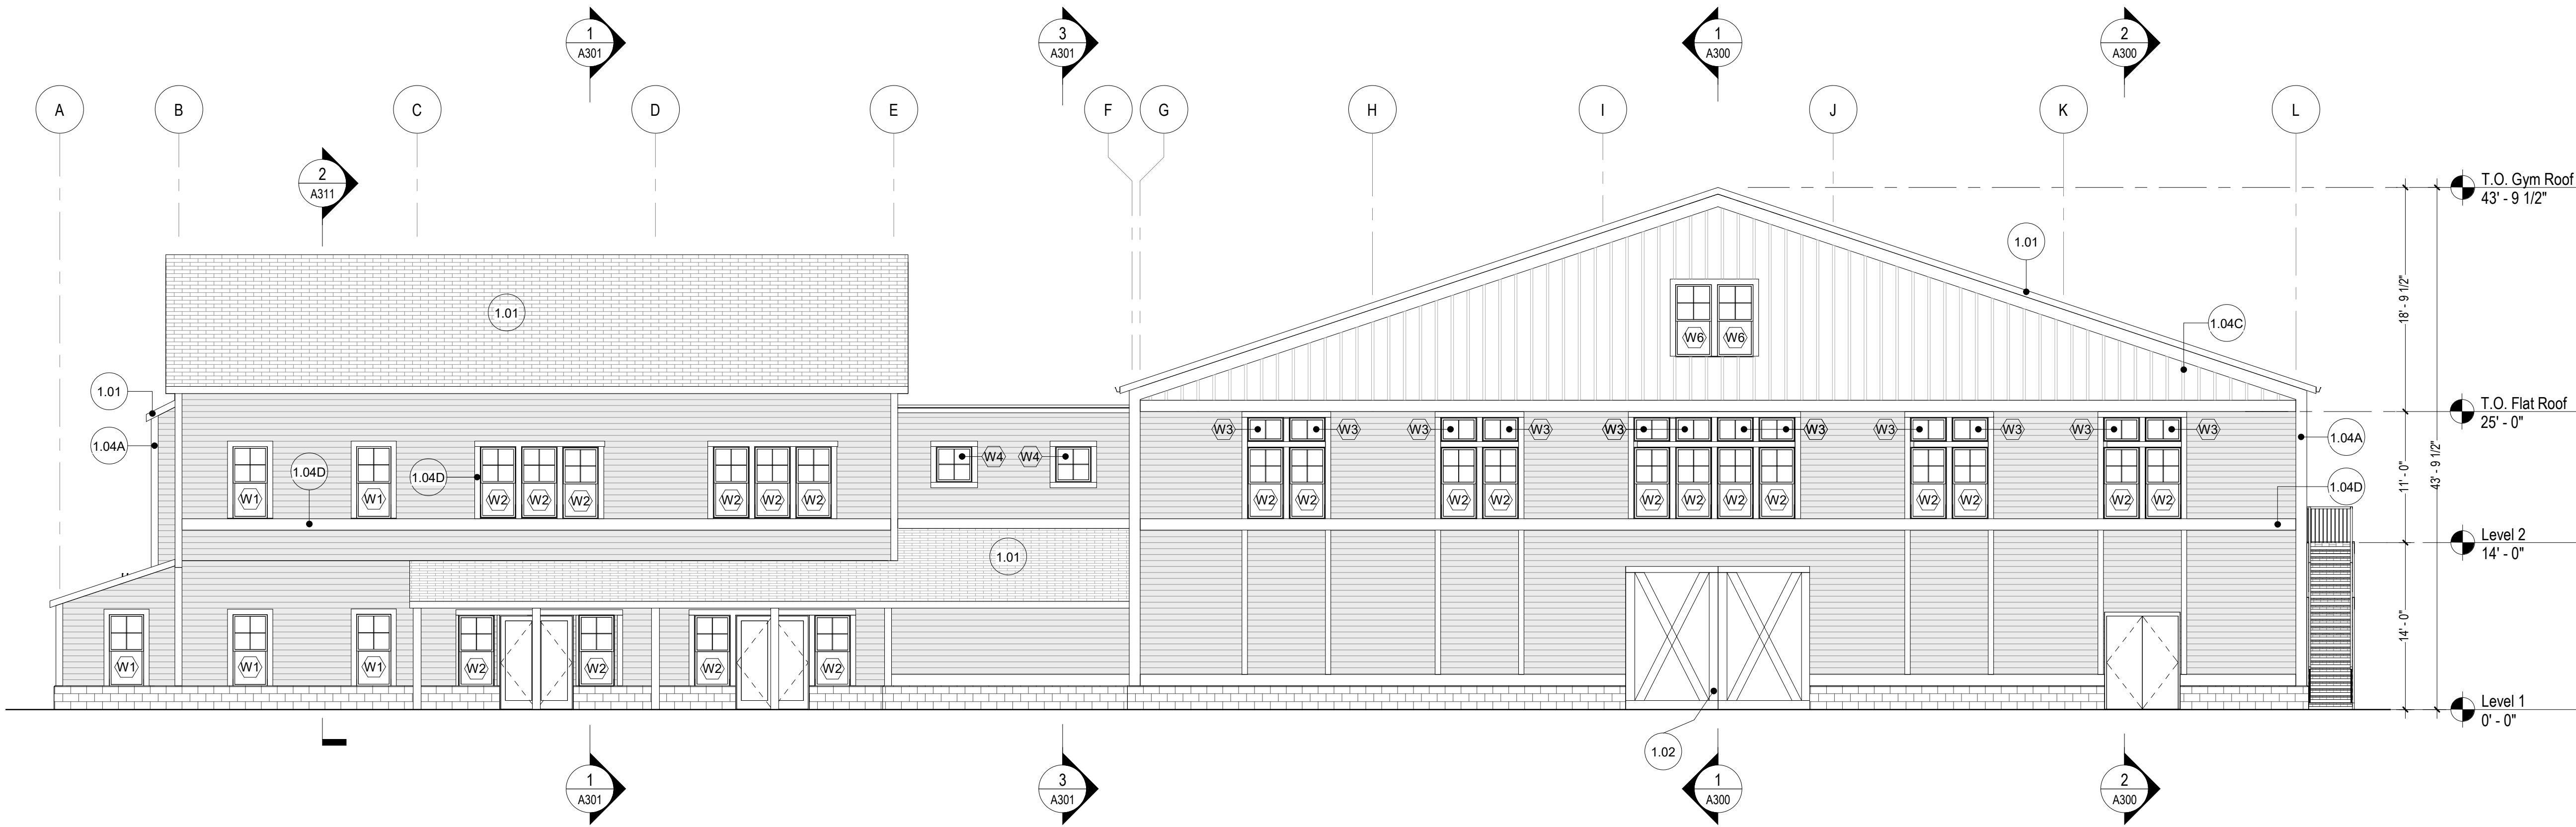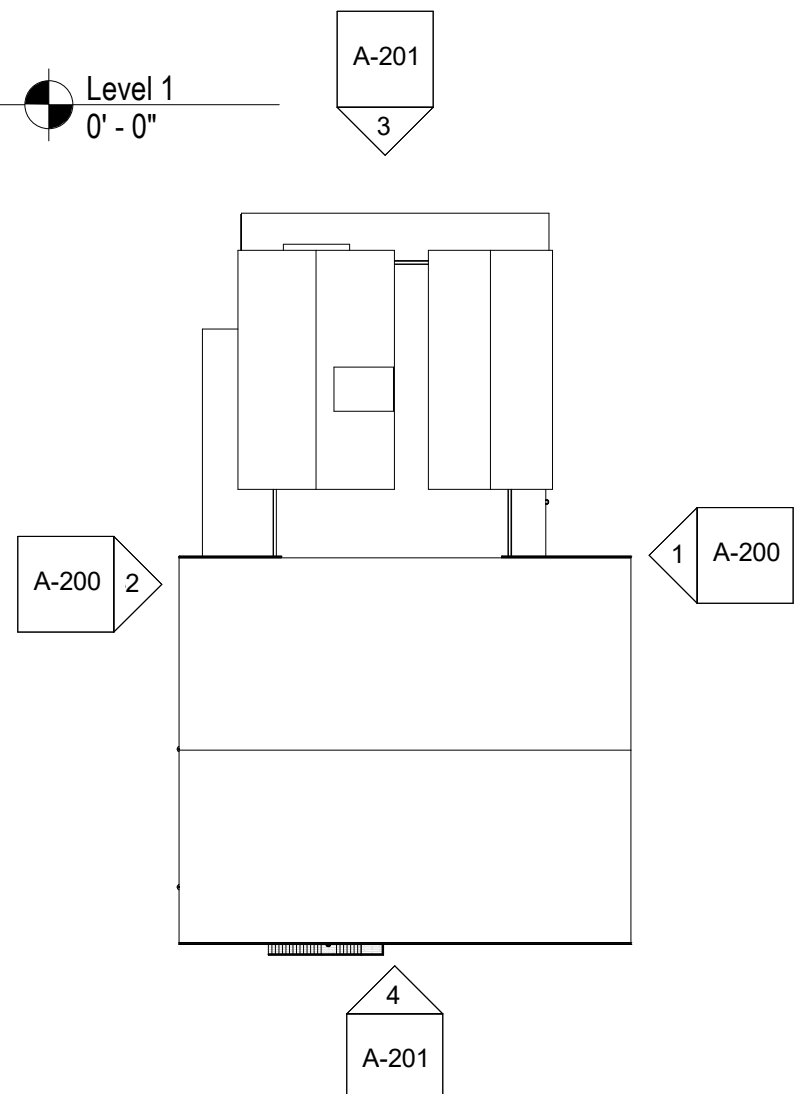


BM 360/Pembroke Community Center/PembrokeCommunityCenter_BM360_FINAL_032822.rvt
5/6/2022 12:01:26 PM
Author

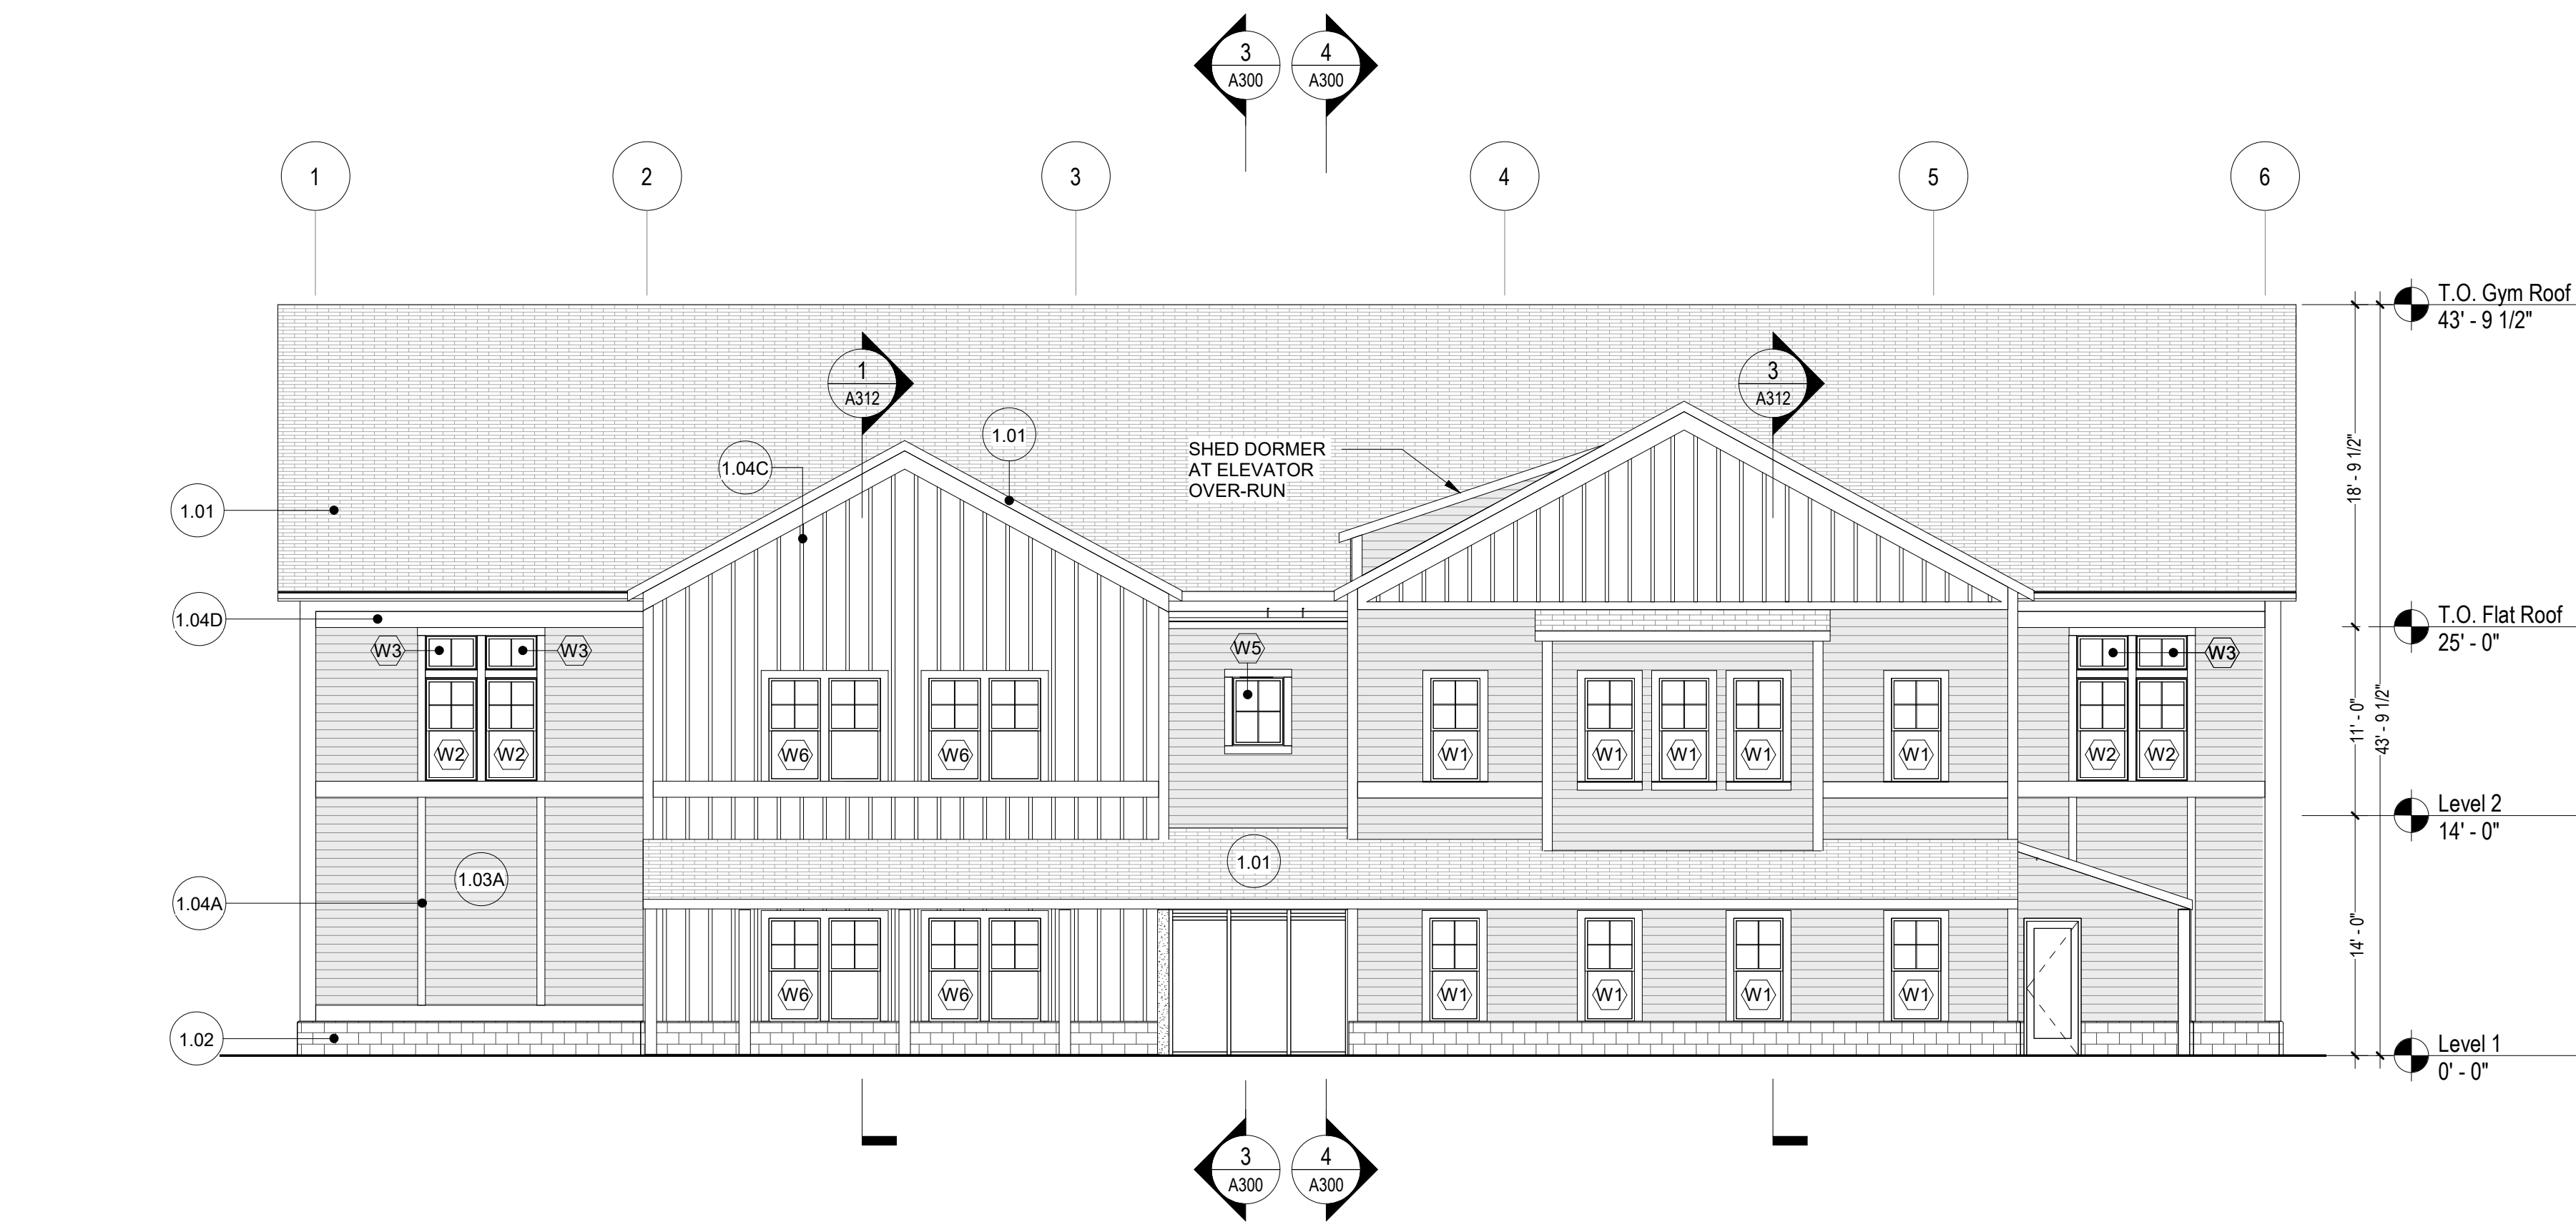

3 NORTH ELEVATION
1/8" = 1'-0"

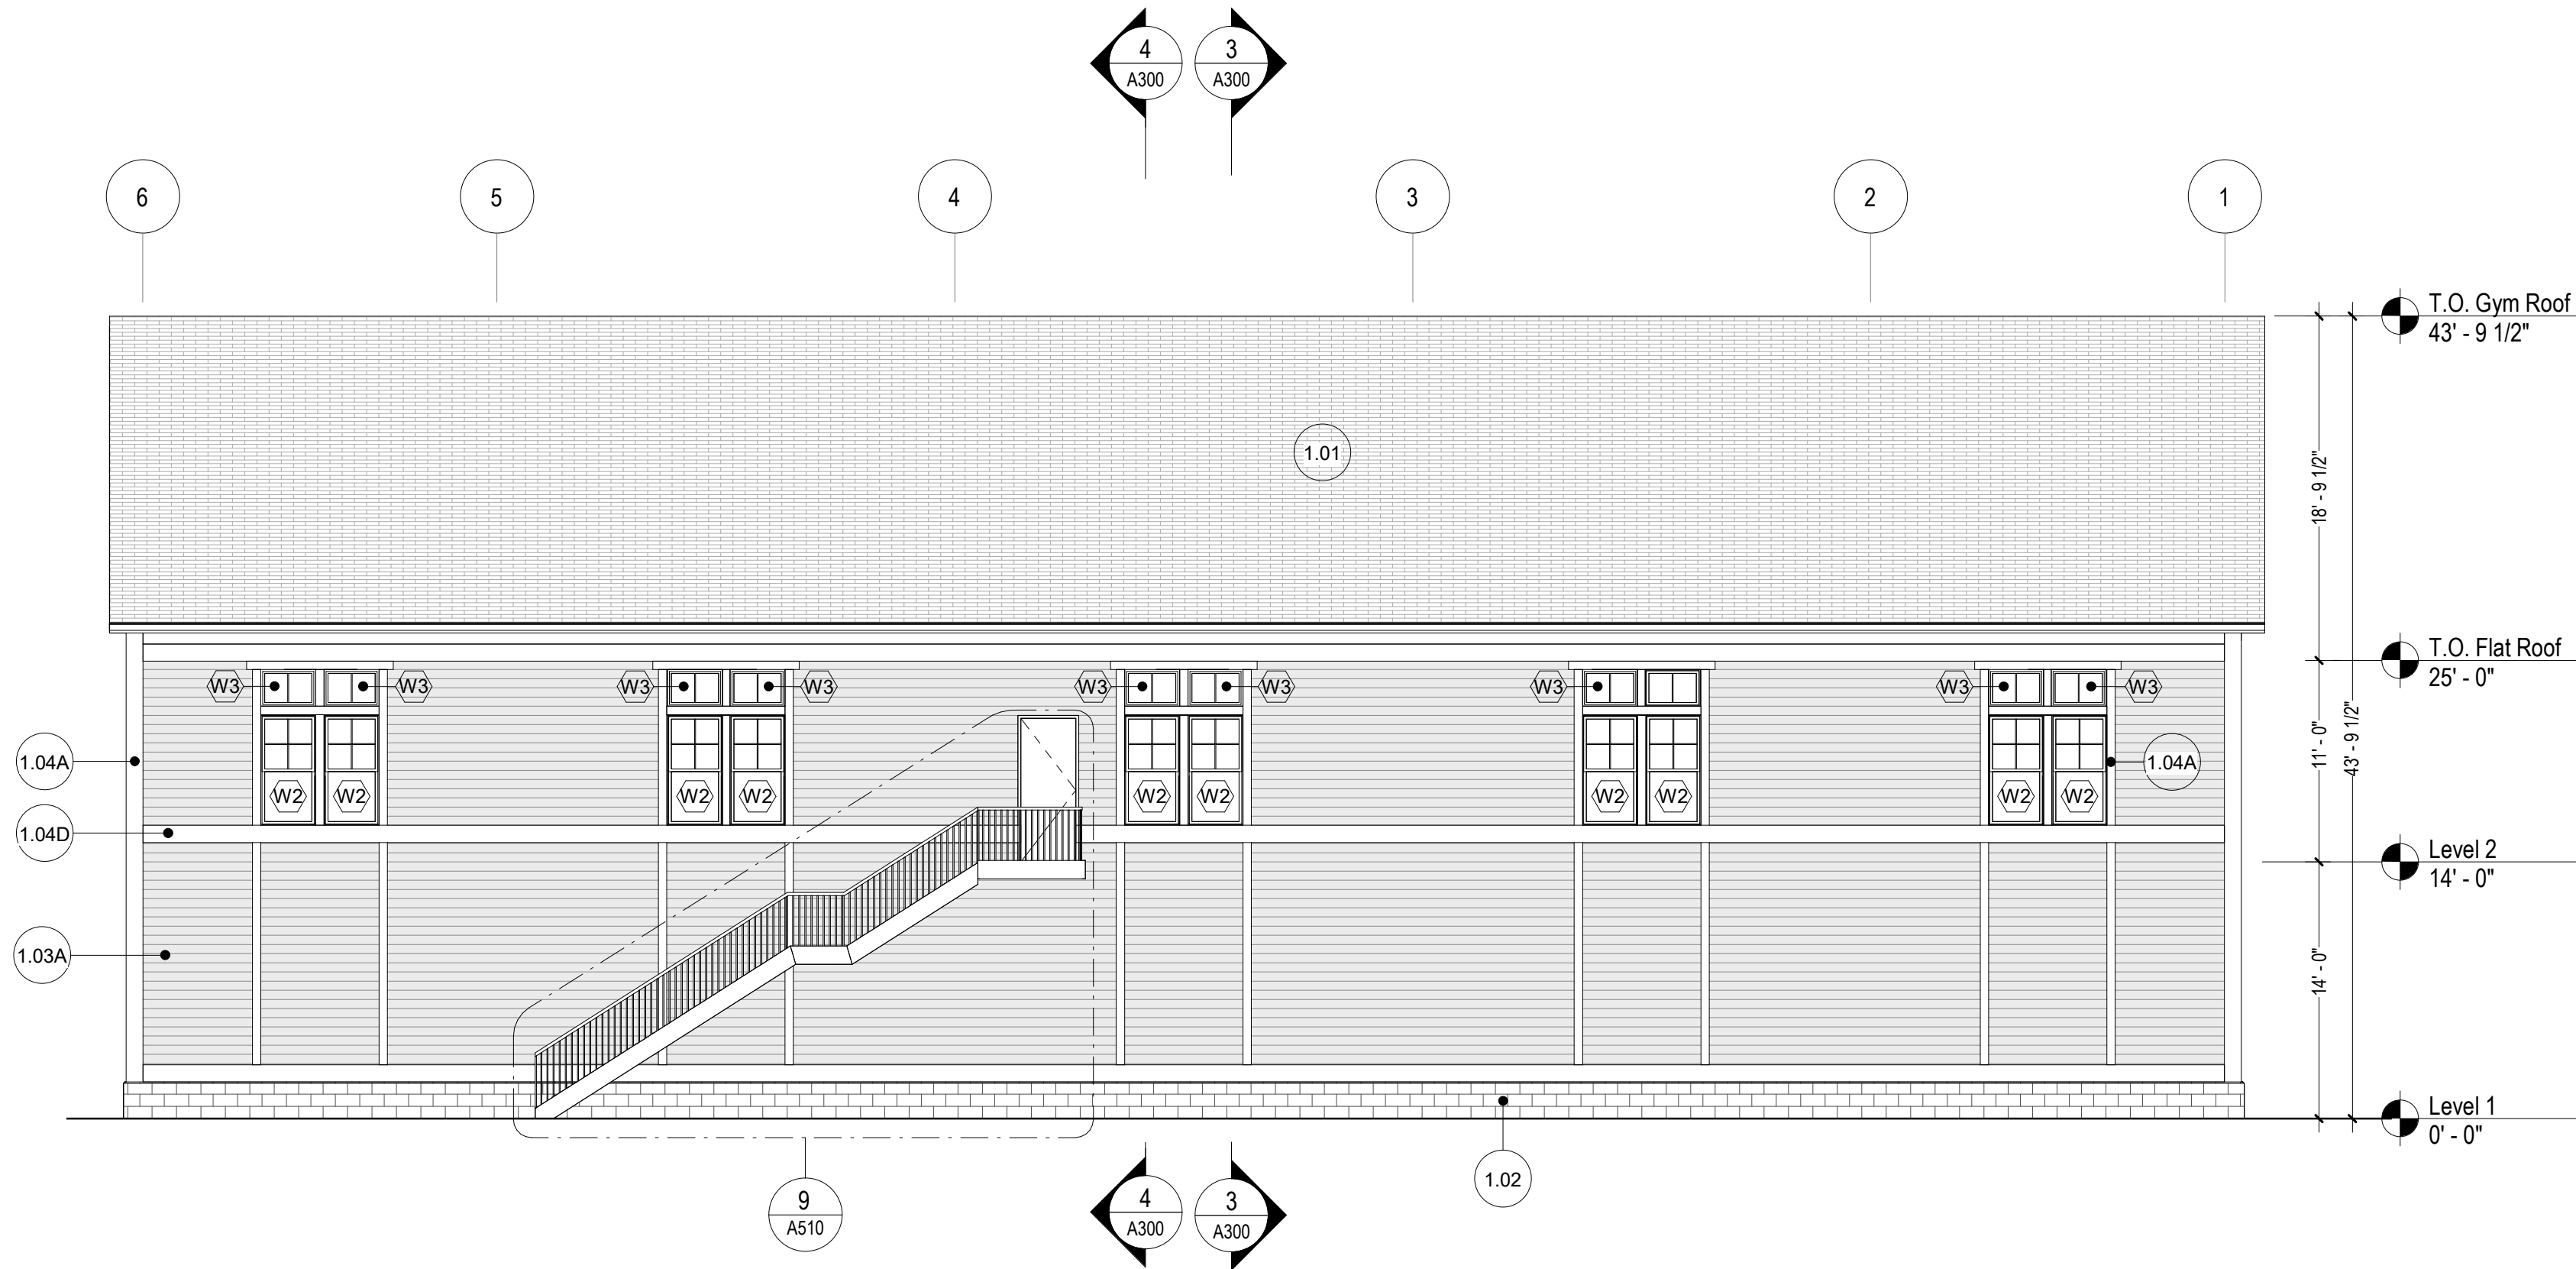

4 SOUTH ELEVATION
1/8" = 1'-0"

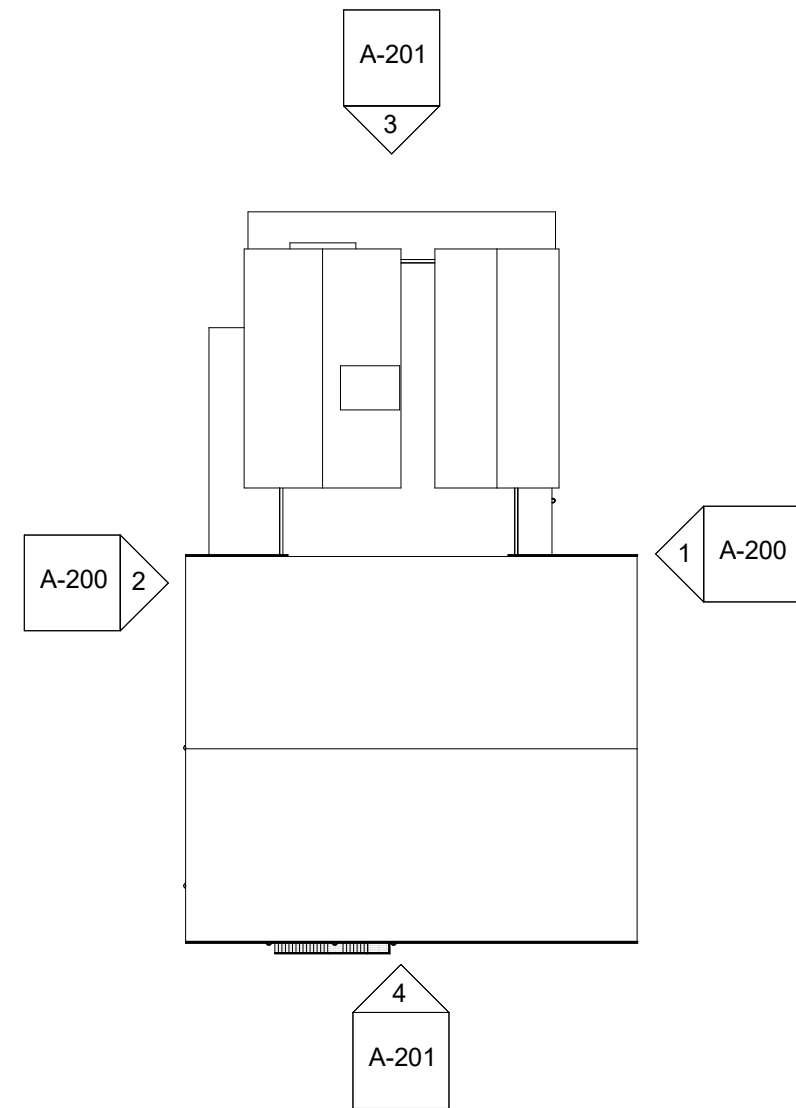

KEY PLAN
1" = 50'-0"

ELEVATION NOTES	
Key Value	Keynote Text
1.01	ASPHALT SHINGLE ROOFING
1.02	MASONRY - GROUND FACE BLOCK - 4X8X16
1.03A	SIDING TYPE 1 - FIBER CEMENT LAP SIDING, 4" EXPOSURE
1.04A	TRIM TYPE 1 - VERTICAL TYPICAL CORNER & DOORWINDOW
1.04C	TRIM TYPE 3 - VERTICAL BATTEN(THIN),...
1.04D	TRIM TYPE 4 - HORIZONTAL,...