



An aerial photograph of a school campus. The central feature is a large, dark-roofed building with a complex, multi-winged layout. To the left of this building is an outdoor basketball court with a red surface and white boundary lines. Several large parking lots are scattered around the campus, many filled with cars. The campus is surrounded by dense green trees and a residential neighborhood with houses and streets. A road with a white line runs horizontally across the lower part of the image, and another road curves along the left side. A grassy field is visible in the upper center of the image.

128 Center Street
Pembroke, MA
Assessors Map D9 Lot 1

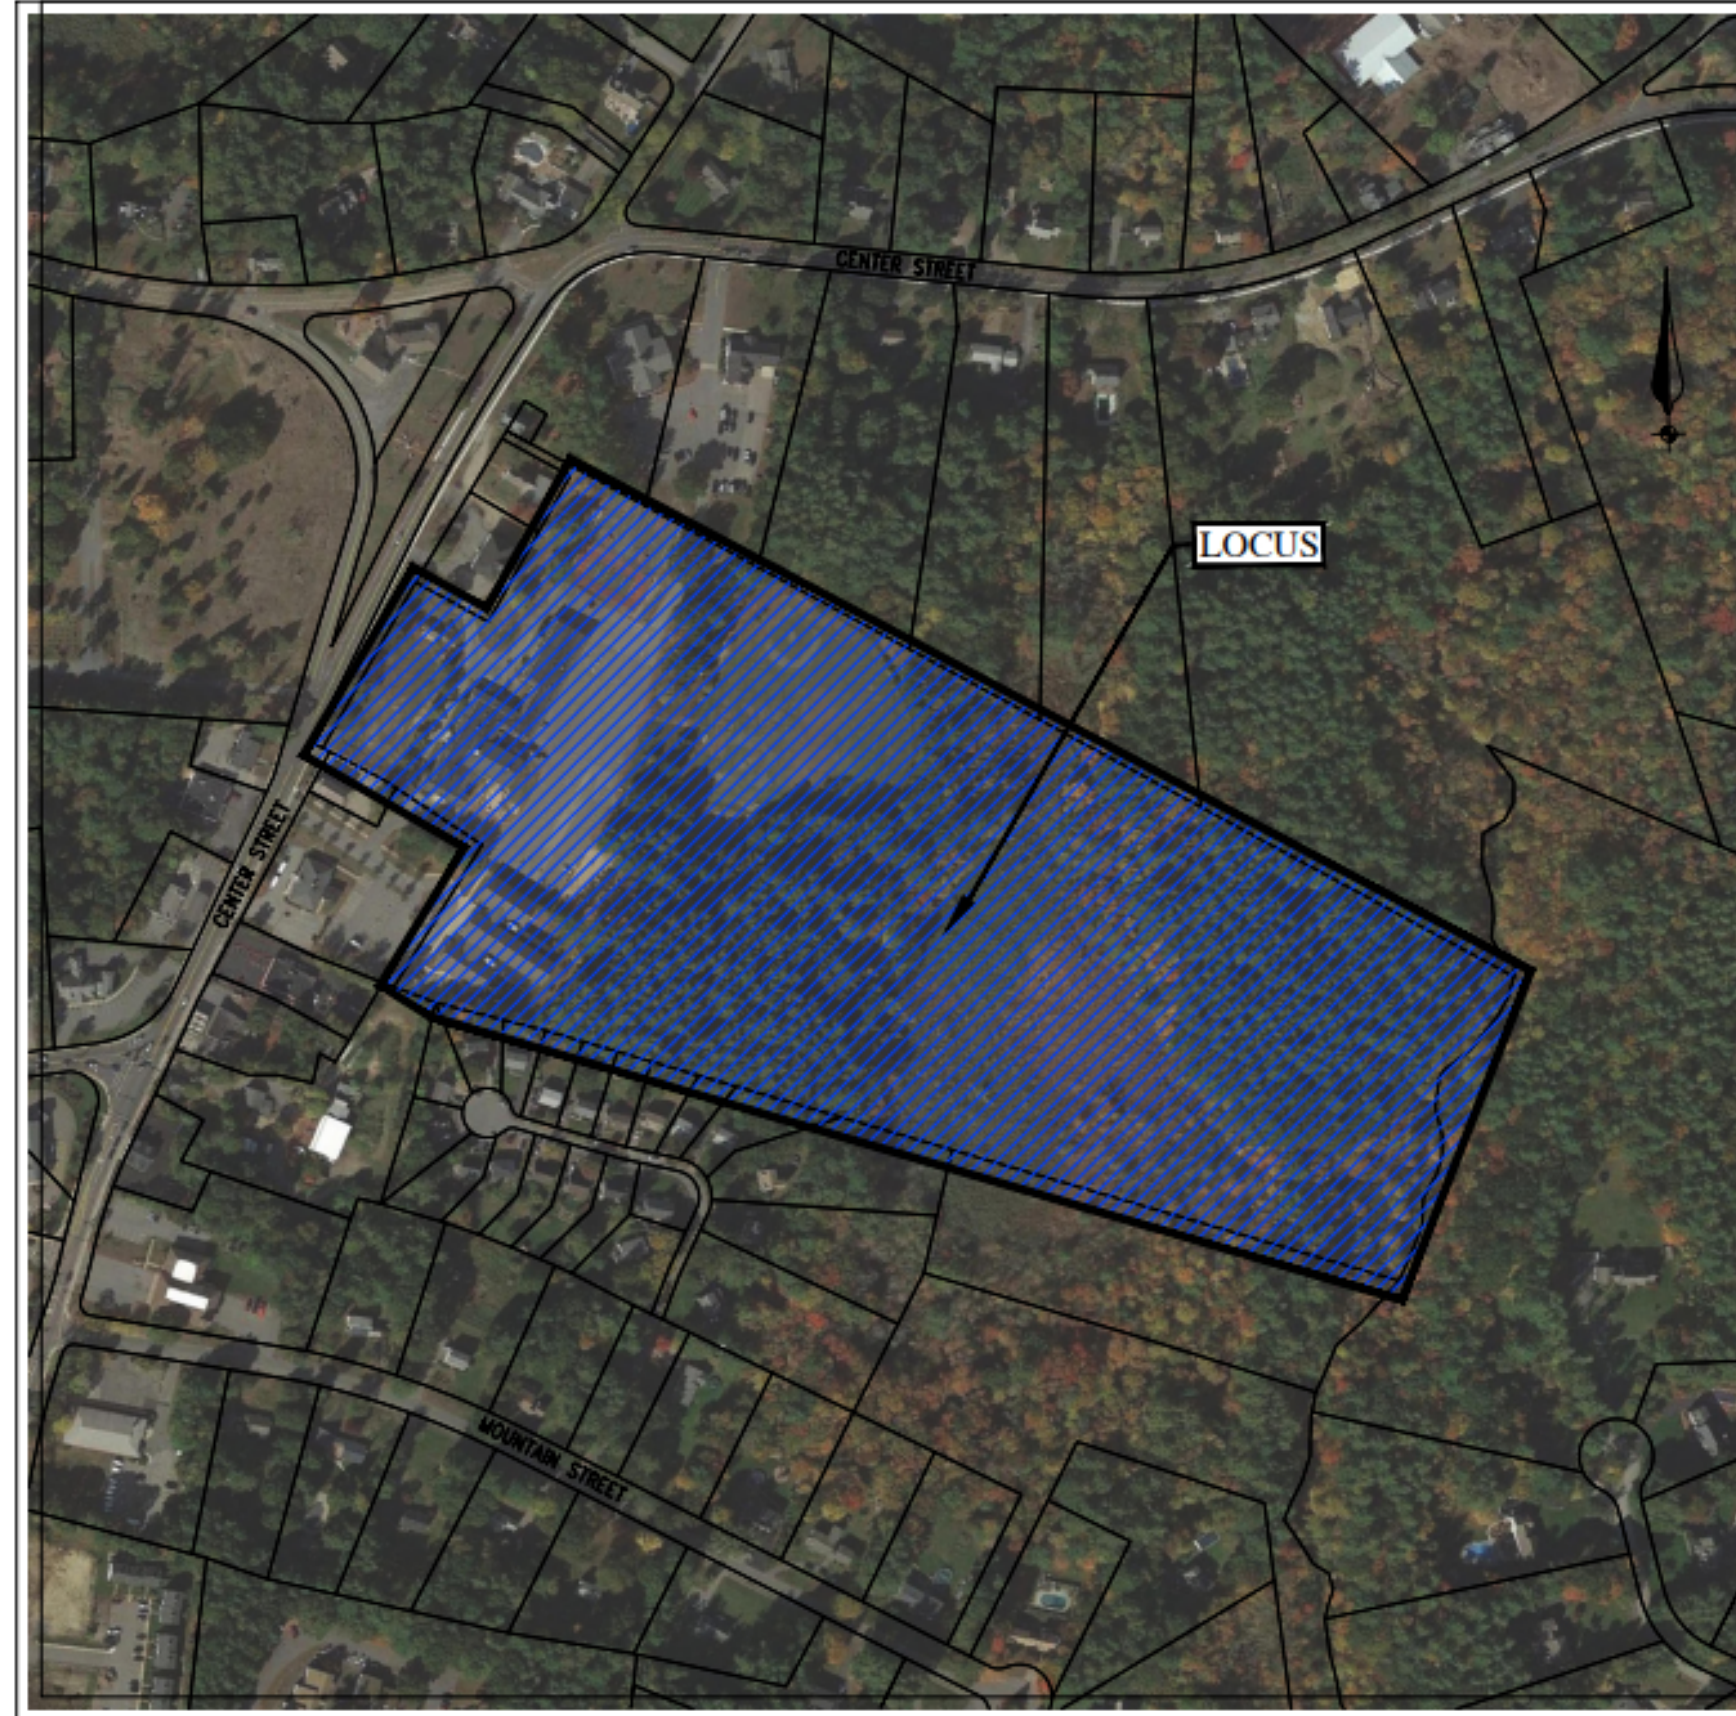



— VICINITY MAP —
SCALE: 1"=200'

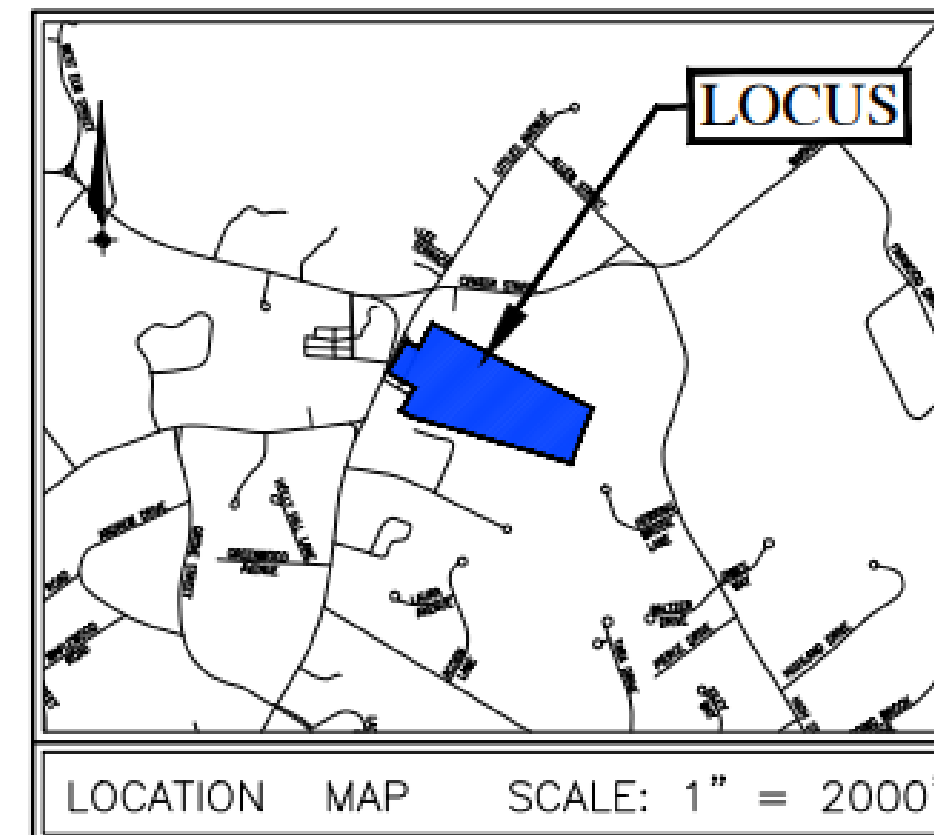

- | | | | |
|-------|-----------------------|-------|-------------------------------------|
| A-000 | Cover Sheet | L100 | Landscape Notes |
| | | L101 | Landscape Materials Plan |
| C101 | Vicinity & Index | L102 | Landscape Materials Plan |
| C201 | Existing Conditions | L103 | Planting Plan |
| C202 | Existing Conditions | L104 | Planting Plan |
| C203 | Existing Conditions | LD1 | Landscape Details |
| C301 | Erosions Control/Demo | LD2 | Landscape Details |
| C302 | Erosions Control/Demo | | |
| C401 | Layout & Zoning | SLP1 | Site Lighting Plan Photometric |
| C402 | Layout & Zoning | | |
| C501 | Grading & Utilities | A-101 | First Floor Plan |
| C502 | Grading & Utilities | A-102 | Second Floor Plan |
| C601 | Site Details | A-103 | Roof Plan |
| C602 | Site Details | A-200 | Exterior Elevations - East & West |
| C603 | Site Details | A-201 | Exterior Elevations - North & South |
| C604 | Site Details | | |

Kyle Zick Landscape Architecture
Boston, MA

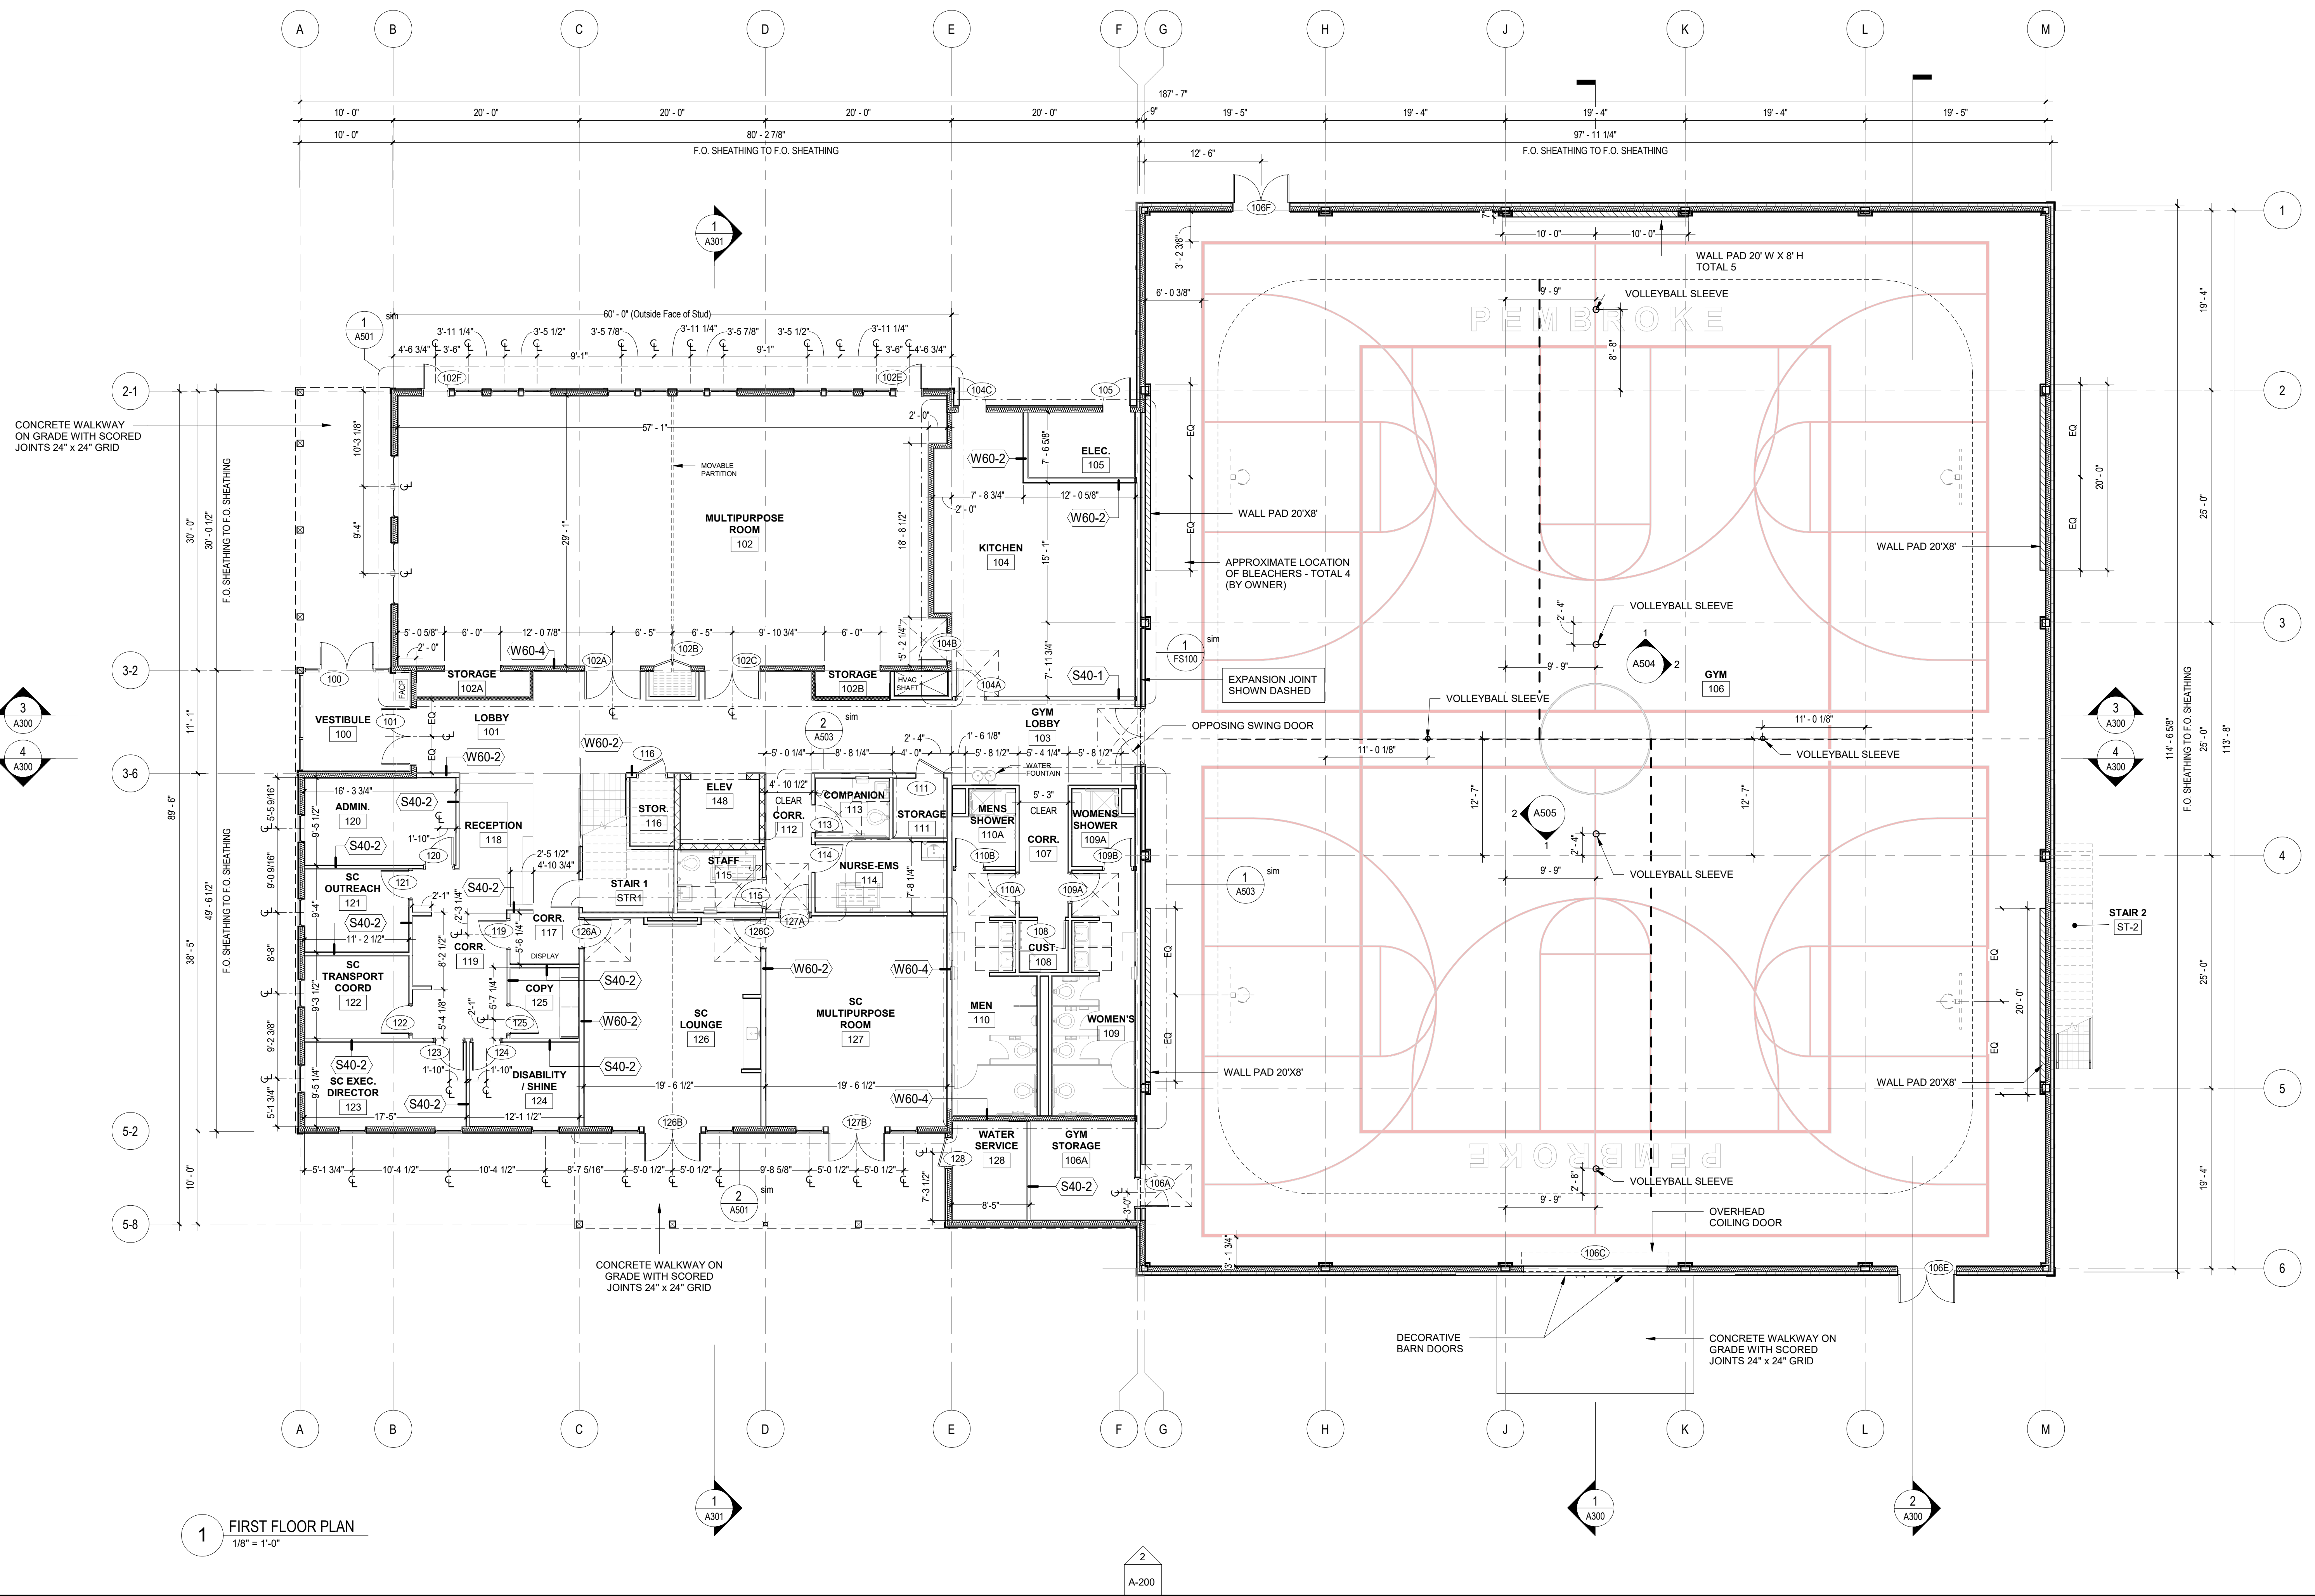

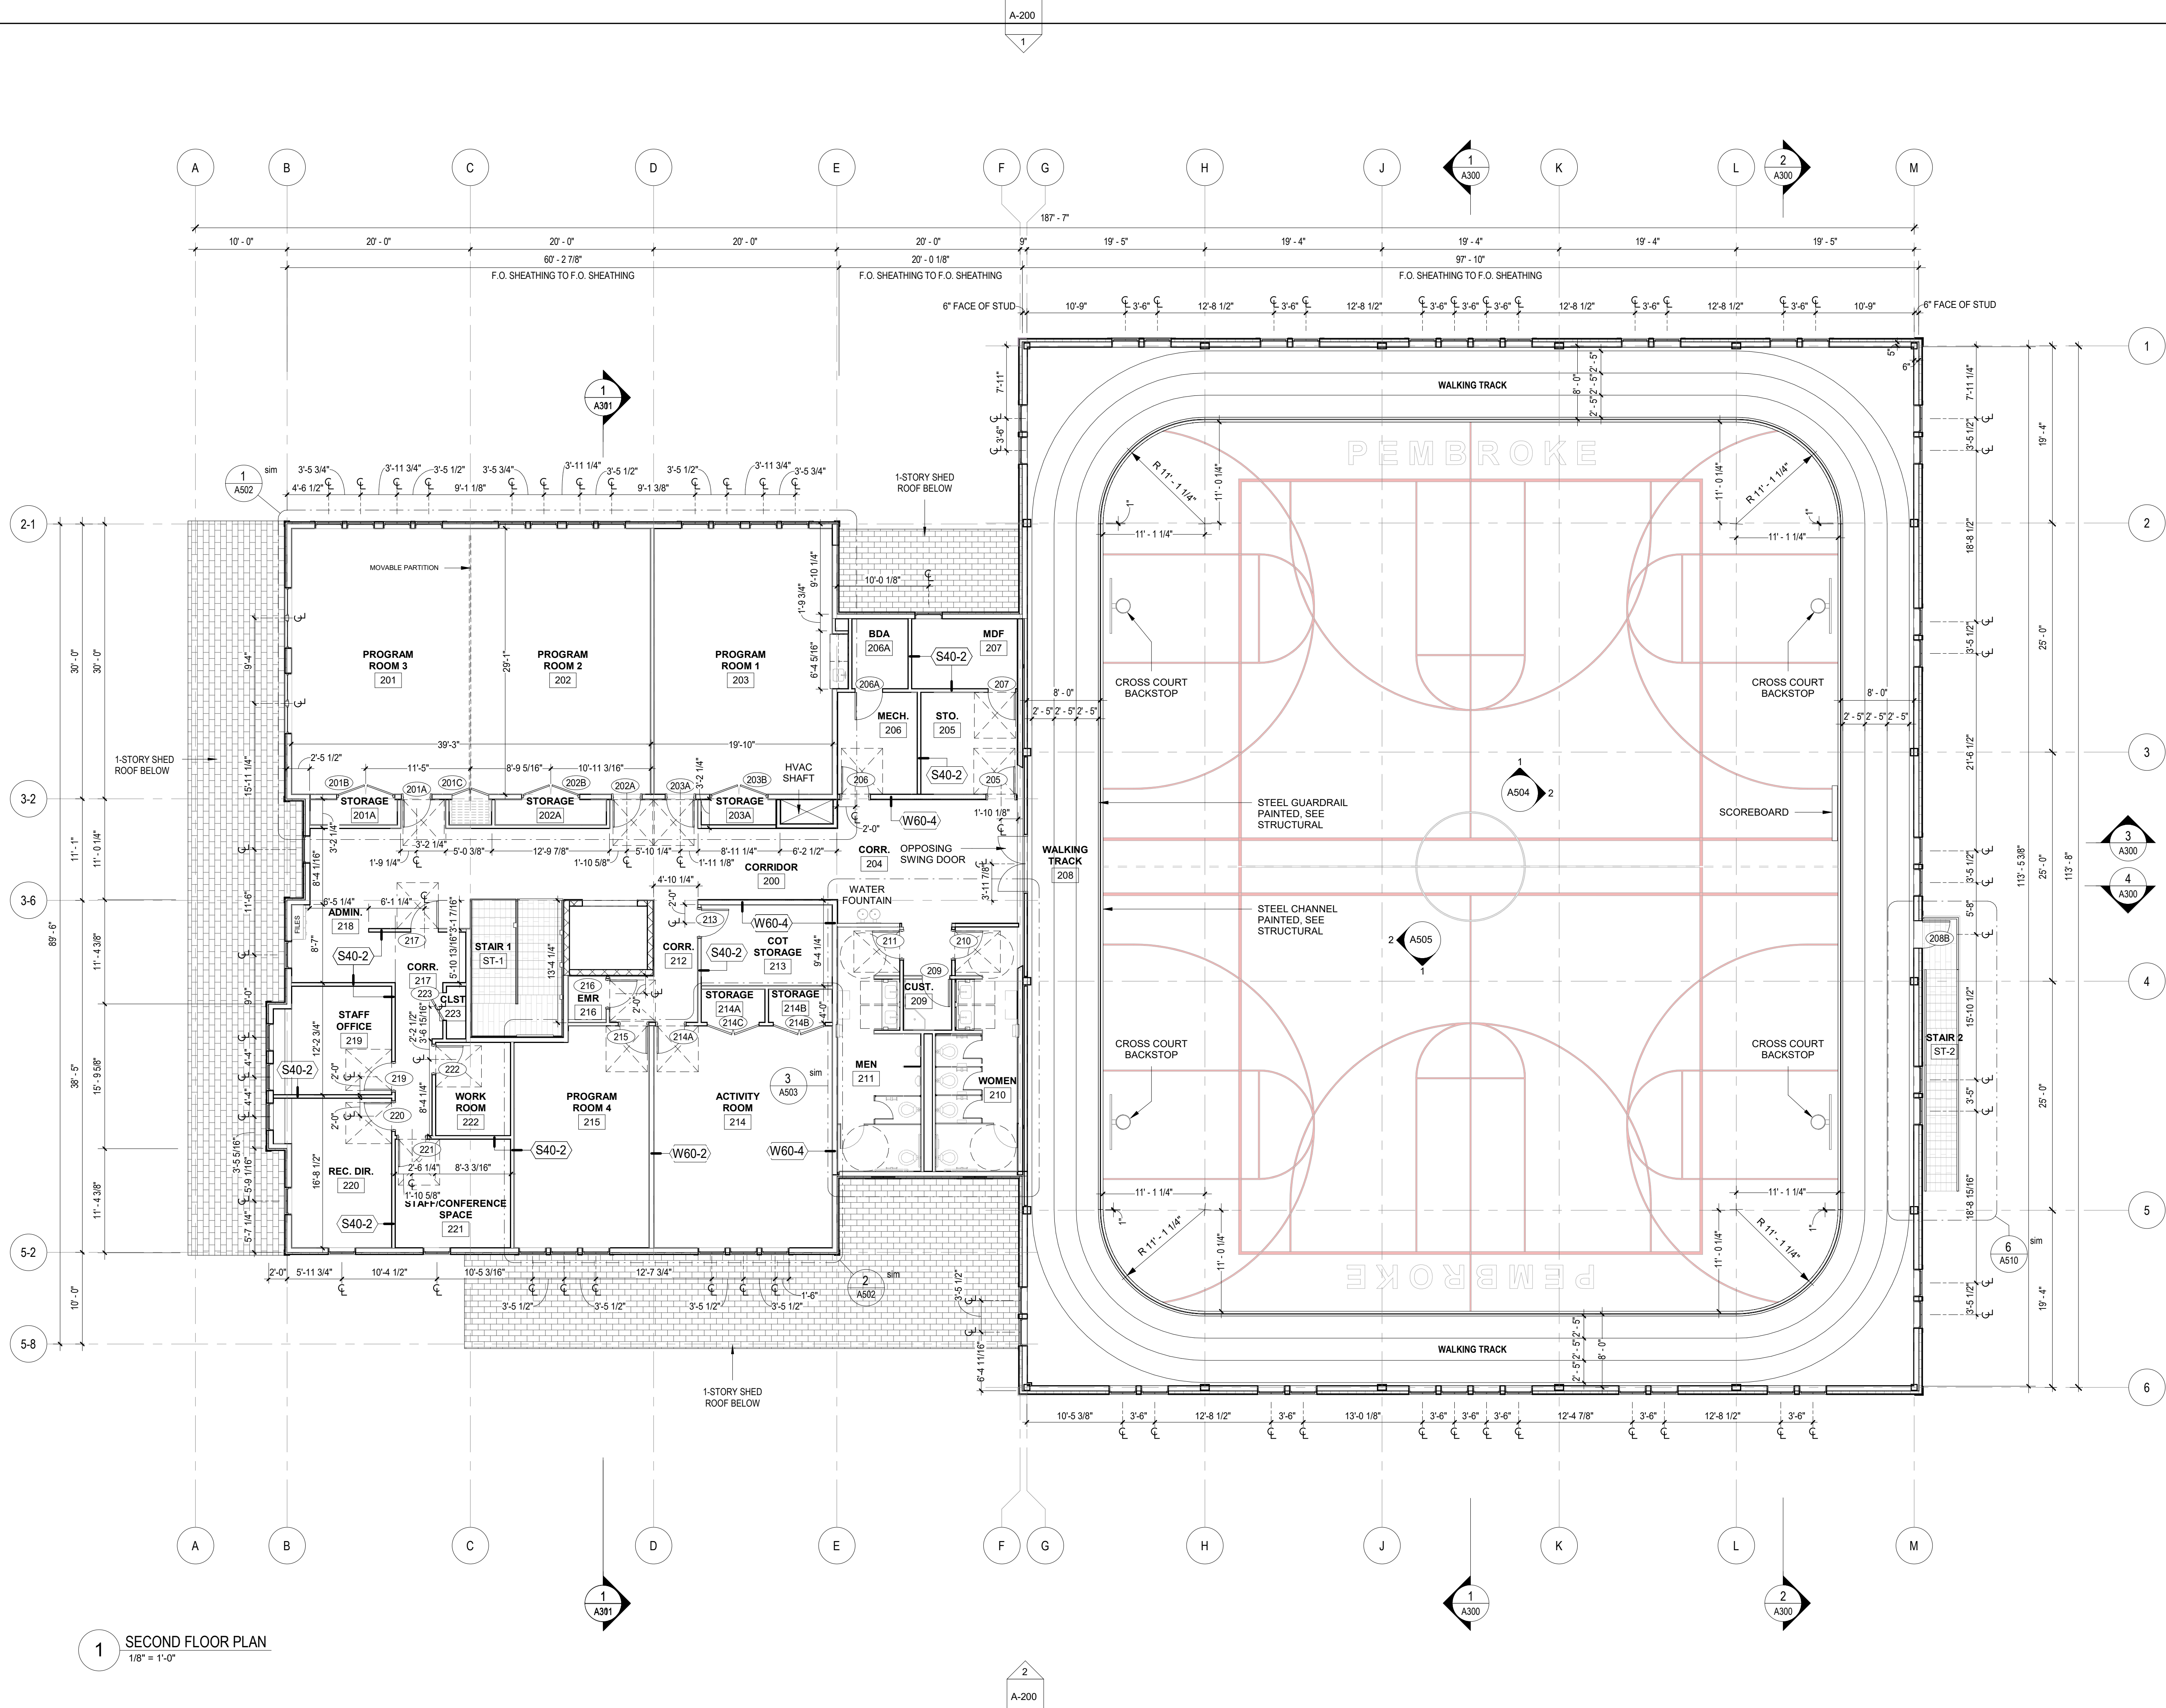

1 SECOND FLOOR PLAN
1/8" = 1'-0"

ARCHITECT

bh+a

Bargmann Hendrie + Archetype, Inc.
9 Channel Center Street, Suite 300
Boston, MA 02210
(617) 350 0450

PROJECT NAME

**Pembroke
Community Center**
128 Center Street
Pembroke, MA, 02359

CLIENT

**Town of
Pembroke MA**
100 Center Street
Pembroke, MA, 02359

PROJECT TEAM

Civil Engineer
Merrill Engineers & Land Surveyors
427 Columbia Road
Hanover, MA, 02339
(781) 826-9200
Landscape Architect
Kyle Zick Landscape Architecture, Inc.
36 Bromfield Street, Suite 202
Boston, MA, 02108
(617) 451-1018
Structural Engineer
Foley Buhl Roberts & Associates, Inc.
2150 Washington Street
Newton, MA, 02462
(617) 527-9600
MEP/FP Engineer
Allied Consulting Engineering Services
235 Littleton Road, Suite 5
Westford, MA, 01886
(978) 443-7888
Geotechnical Engineer
McArdle Cannon Associates, Inc.
300 Oak Street, Suite 460
Pembroke, MA 02359
(781) 826-0040
Elevator Consultant
B Squared Engineering
169 Mill Brook Road
Stamford, CT, 06902
(203) 989-9029
Food Service Consultant
Crabtree McGrath Associates
161 West Main Street
Georgetown, MA 01833
(978) 352-8500

REVISIONS

NO.	DESCRIPTION	DATE

July 6, 2022

DATE

DRAWING TITLE

Second Floor Plan

DRAWING INFORMATION

May 6, 2022
DATE OF ISSUE
Final PB Rev's
DESCRIPTION
1/8" = 1'-0"
SCALE
3403.00
PROJECT #


Author
DRAWN BY
Pembroke
FILE NAME

DRAWING NUMBER


A-102

Copyright BH+A, Inc.



V.2.1

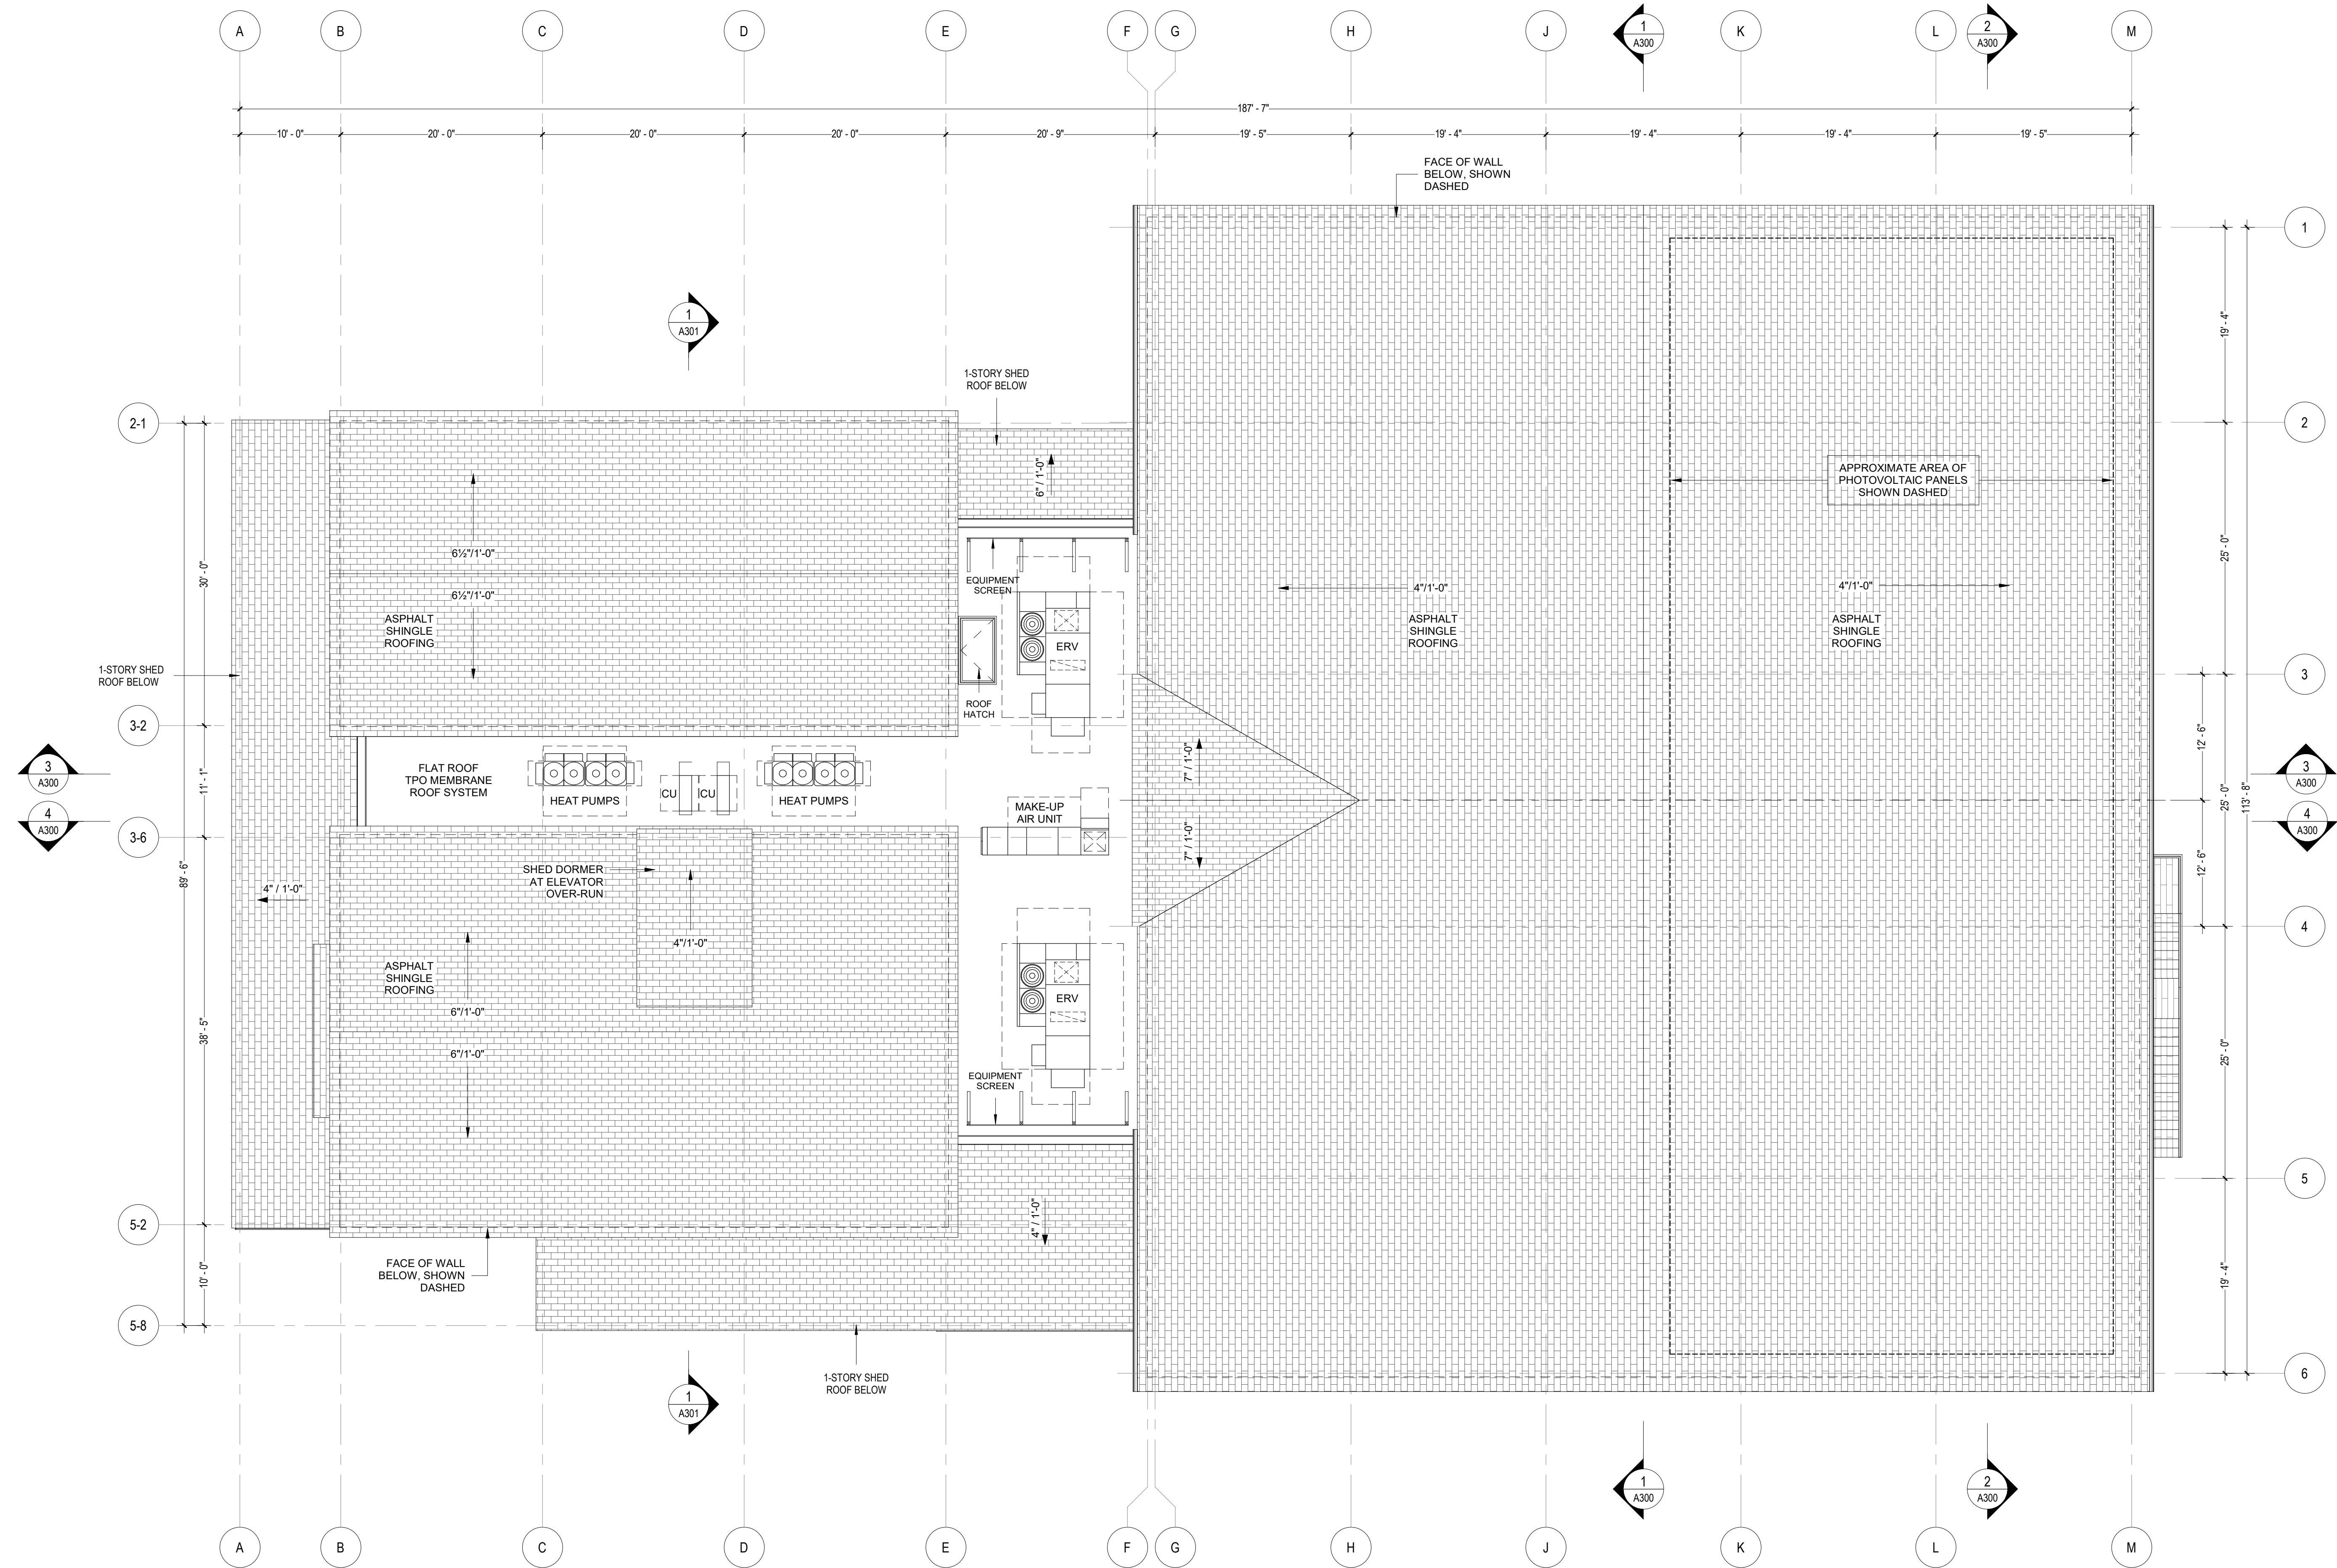


1 ROOF PLAN
1/8" = 1'-0"

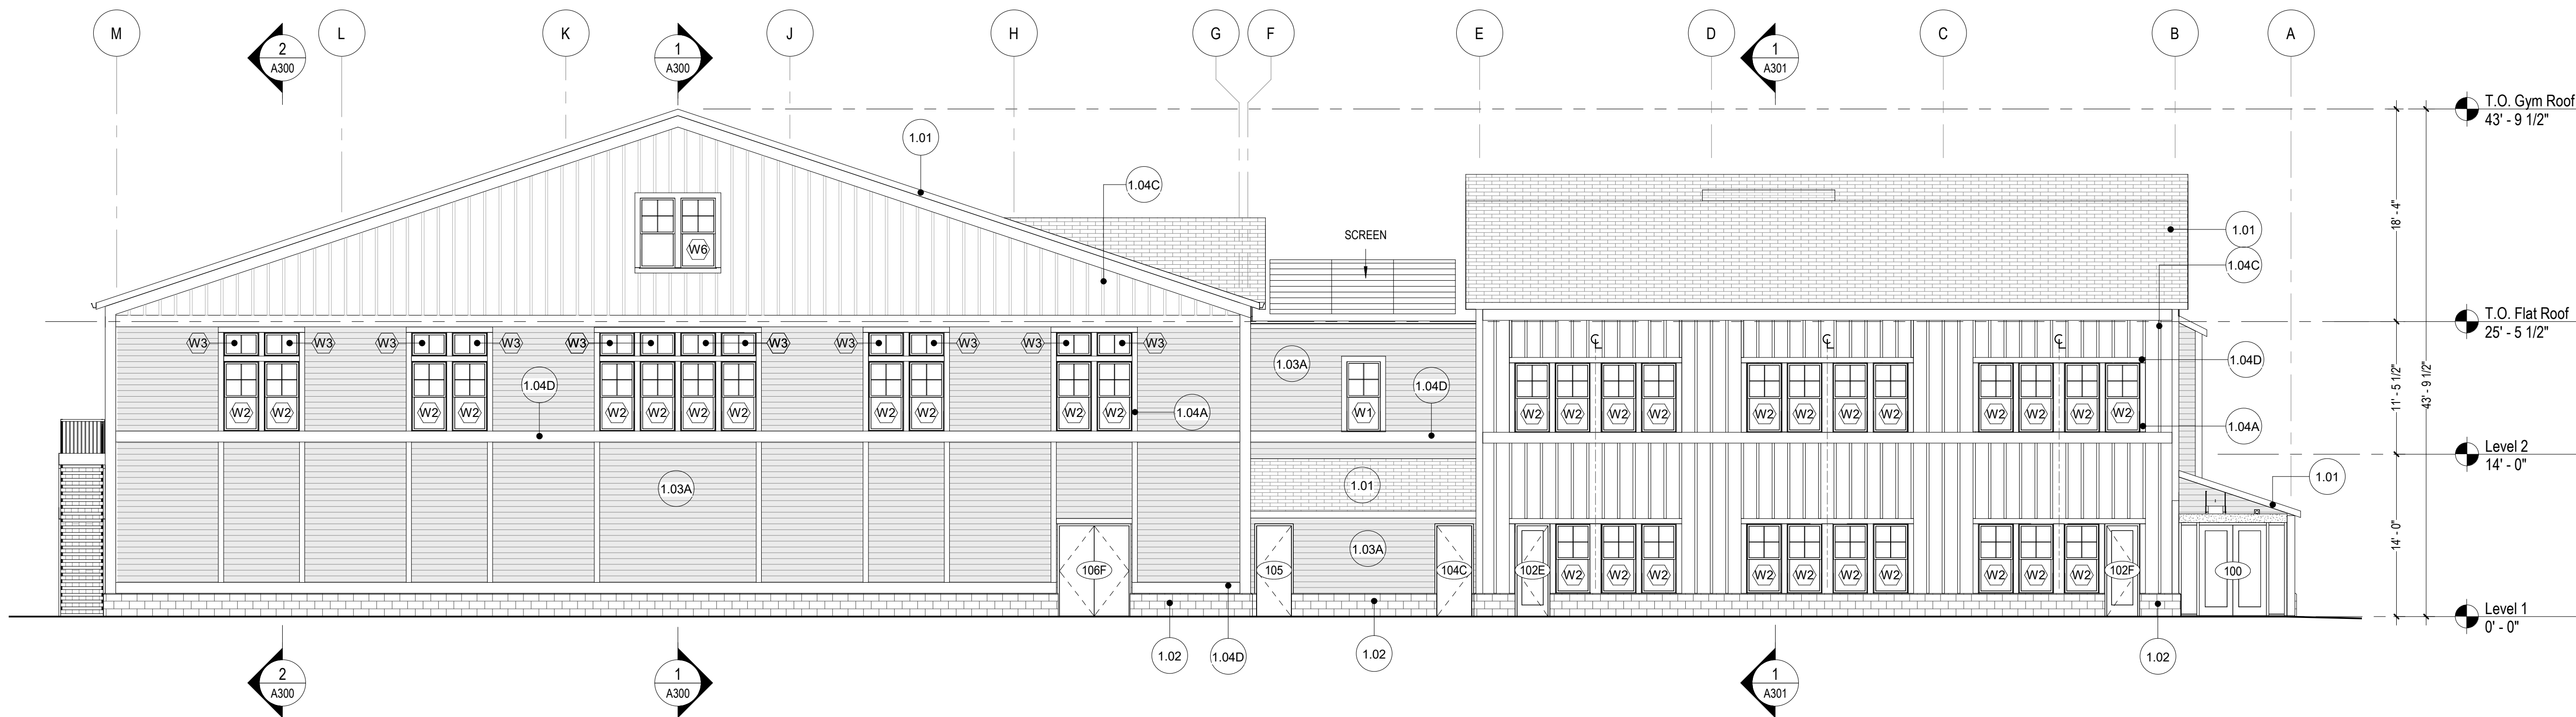


ELEVATION NOTES	
Key Value	Keynote Text
1.01	ASPHALT SHINGLE ROOFING
1.02	MASONRY - GROUND FACE BLOCK - 4X8X16
1.03A	SIDING TYPE 1 - FIBER CEMENT LAP SIDING, 4" EXPOSURE
1.04A	TRIM TYPE 1 - VERTICAL TYPICAL CORNER & DOOR/WINDOW
1.04C	TRIM TYPE 3 - VERTICAL BATTEN (THIN)
1.04D	TRIM TYPE 4 - HORIZONTAL

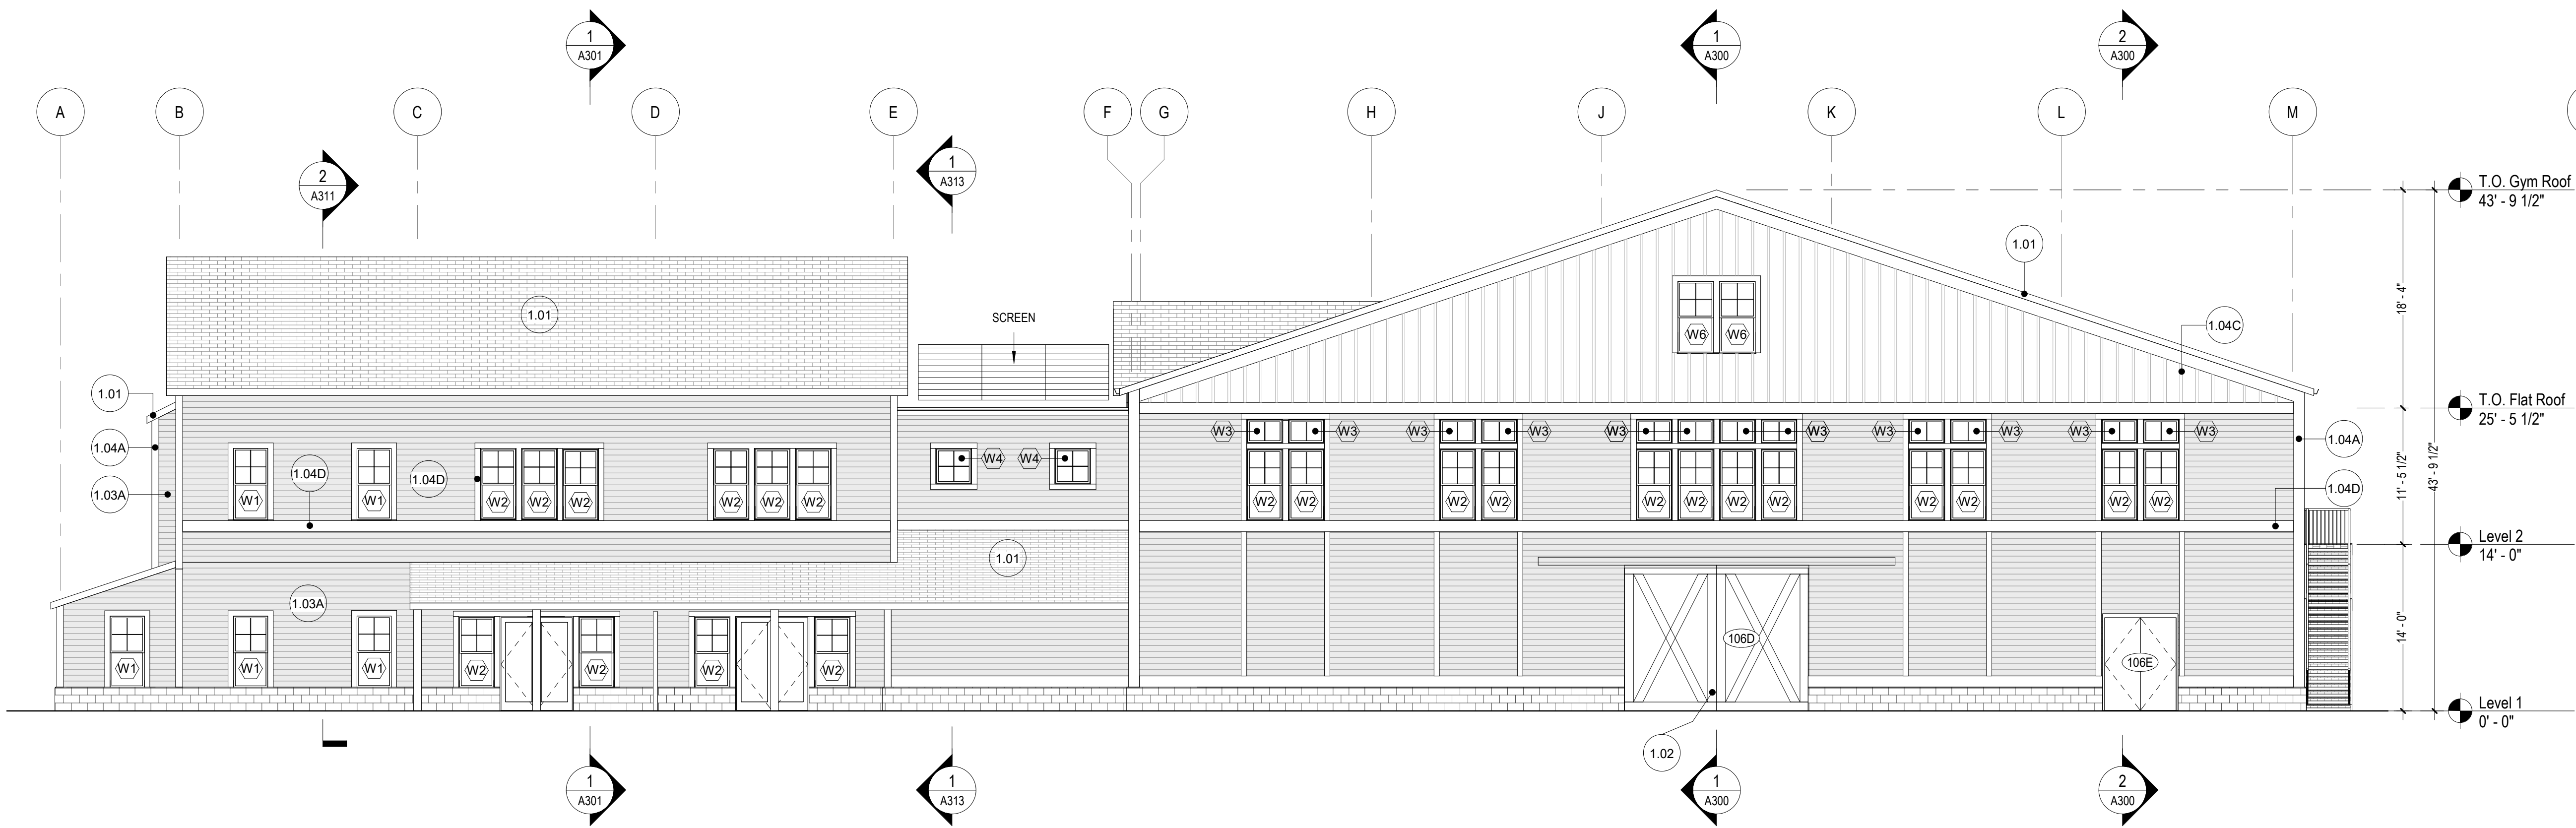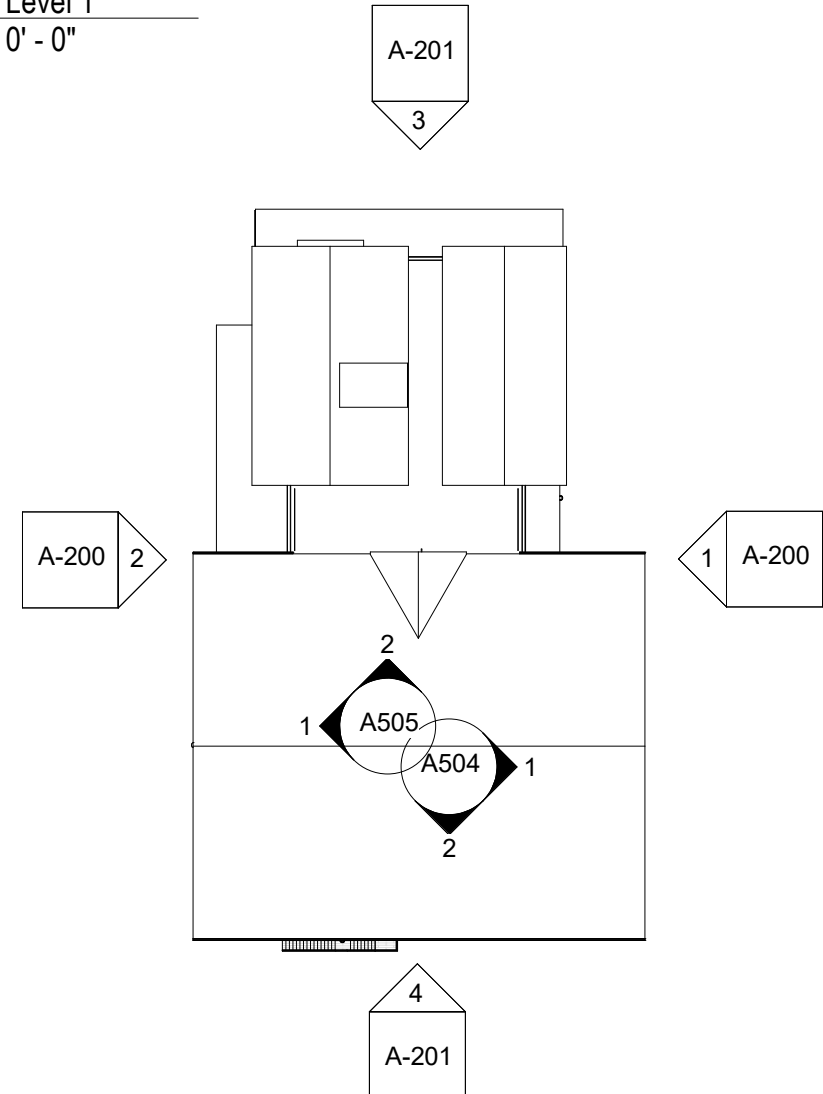


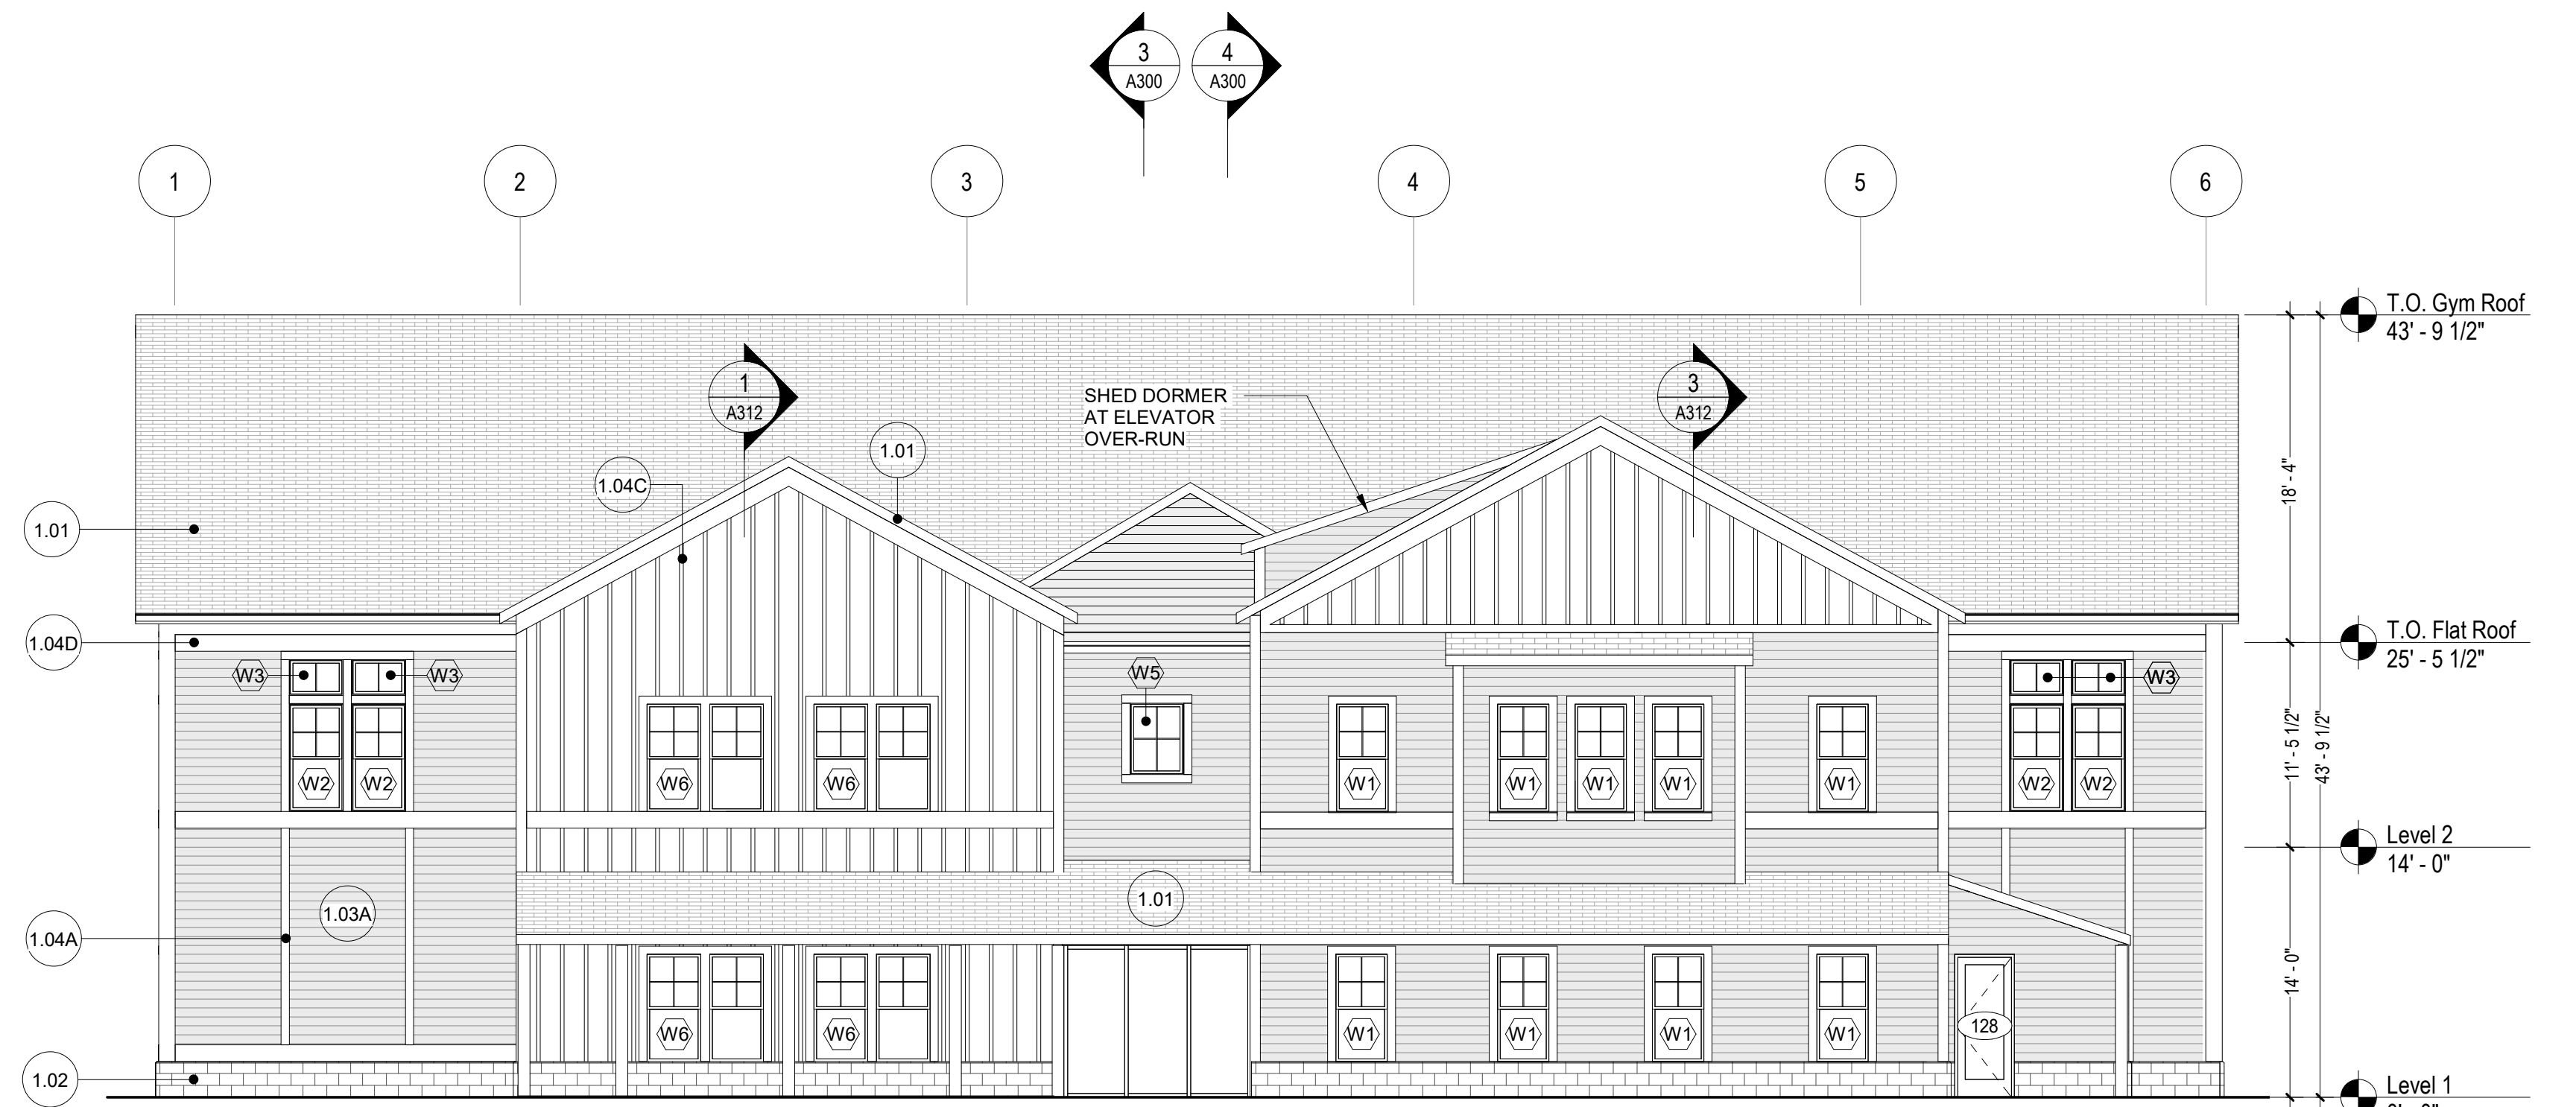

3 NORTH ELEVATION
1/8" = 1'-0"

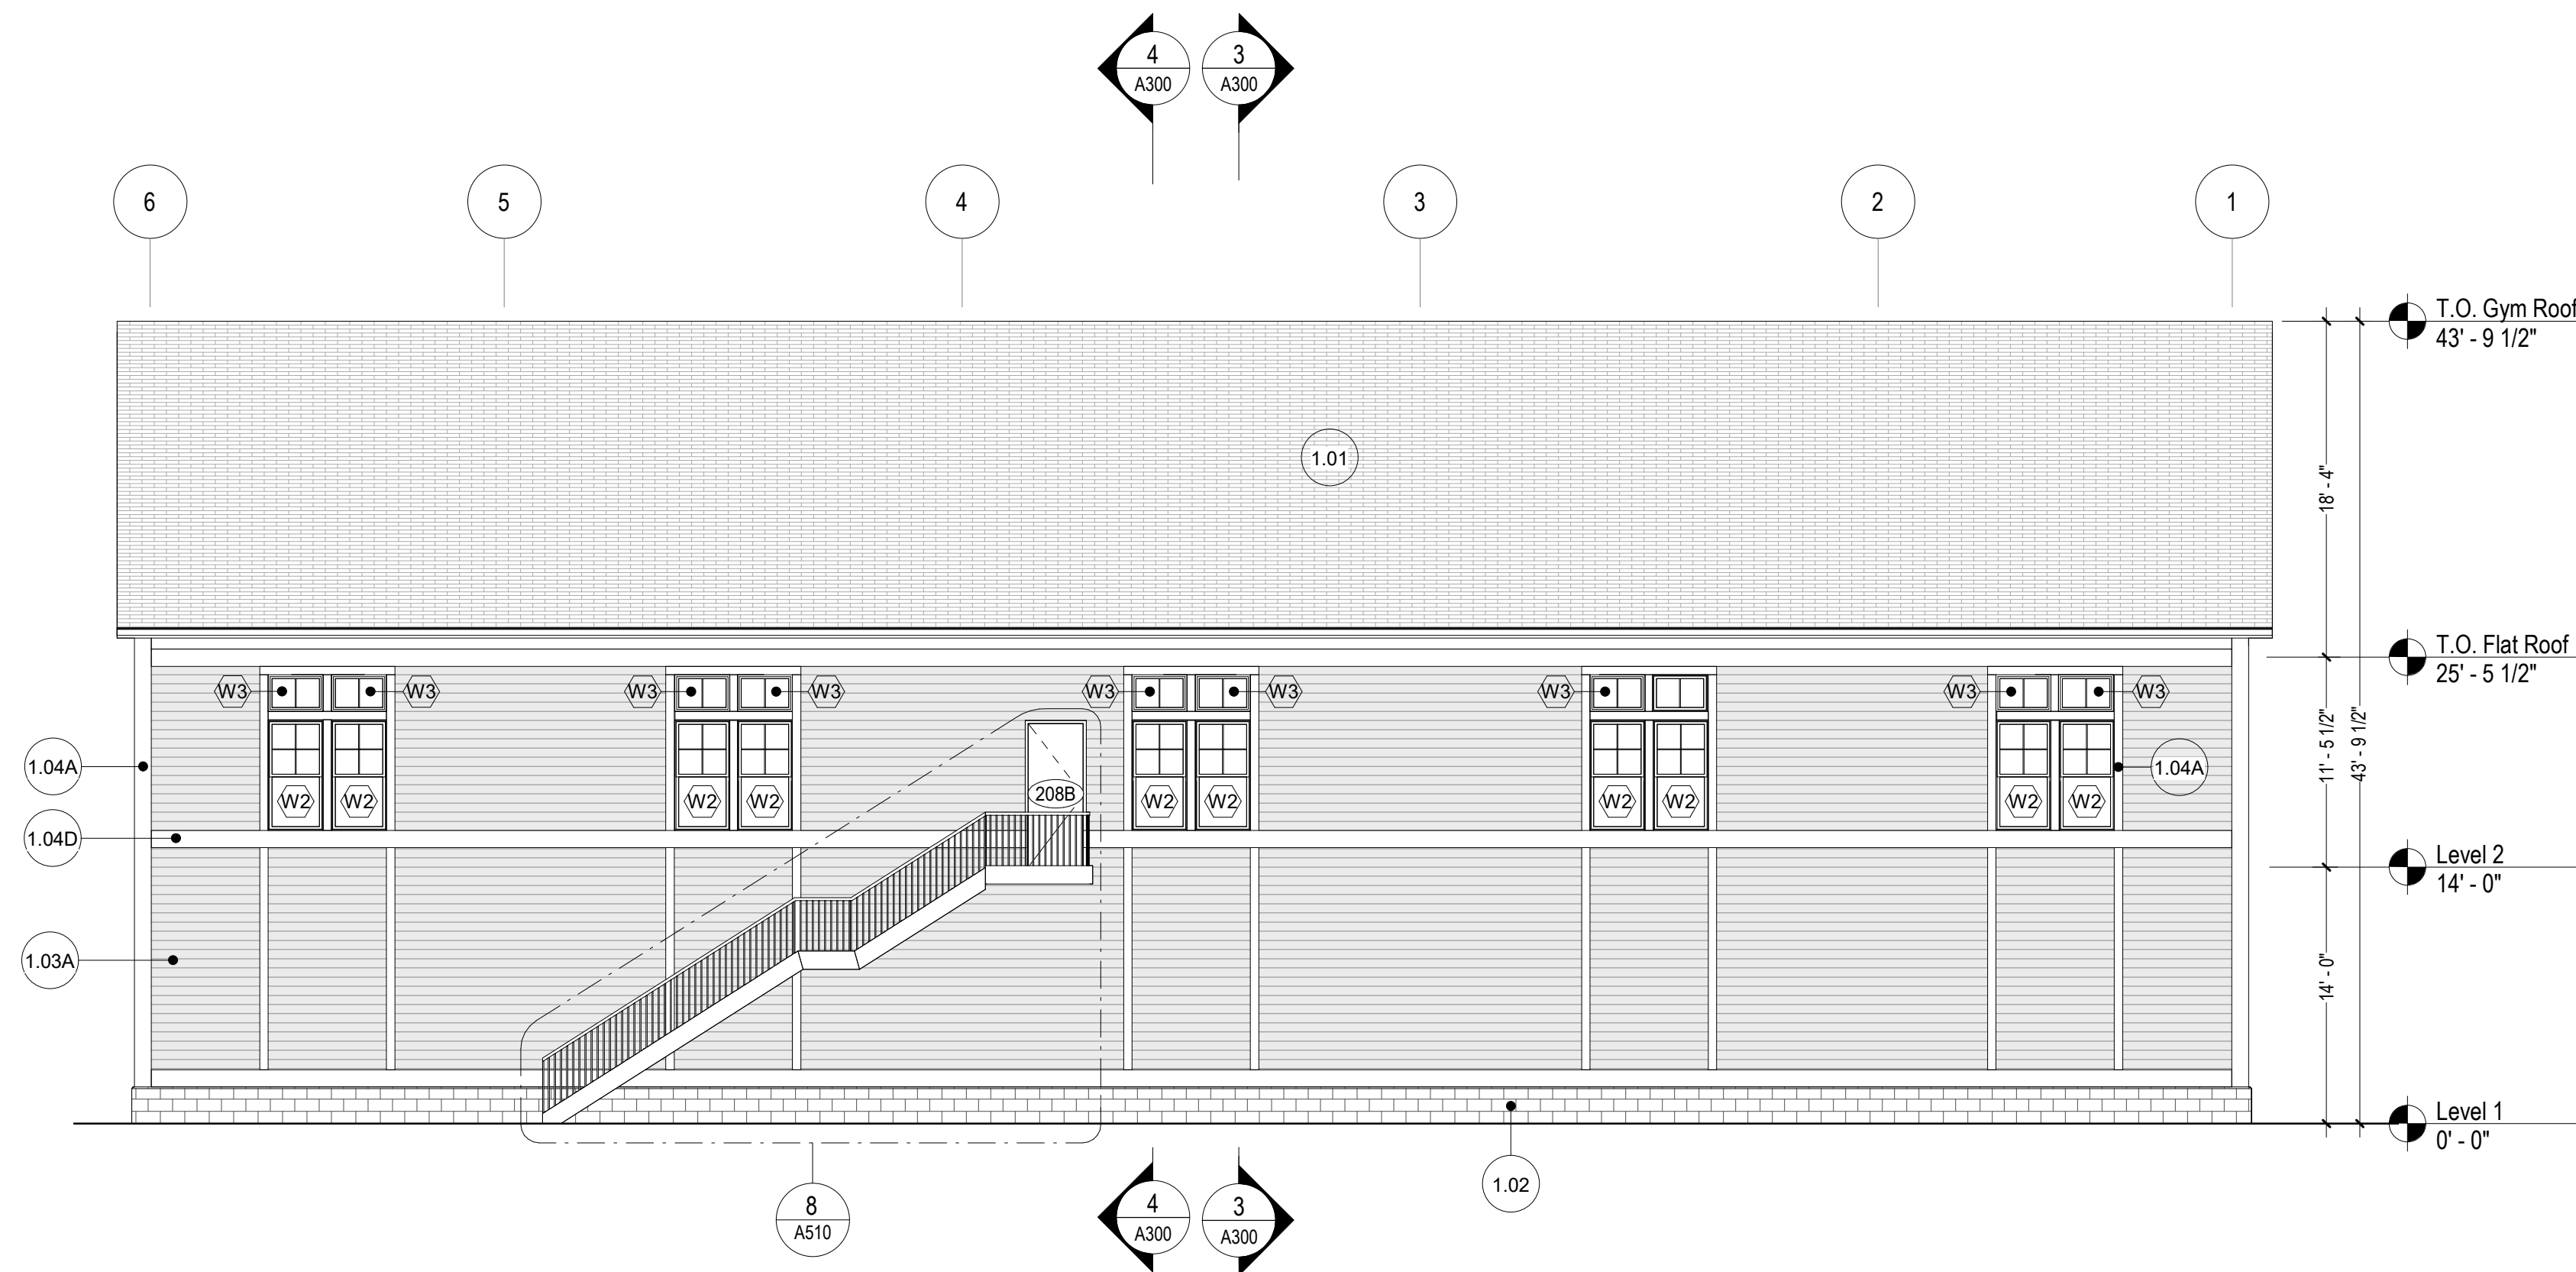

4 SOUTH ELEVATION
1/8" = 1'-0"

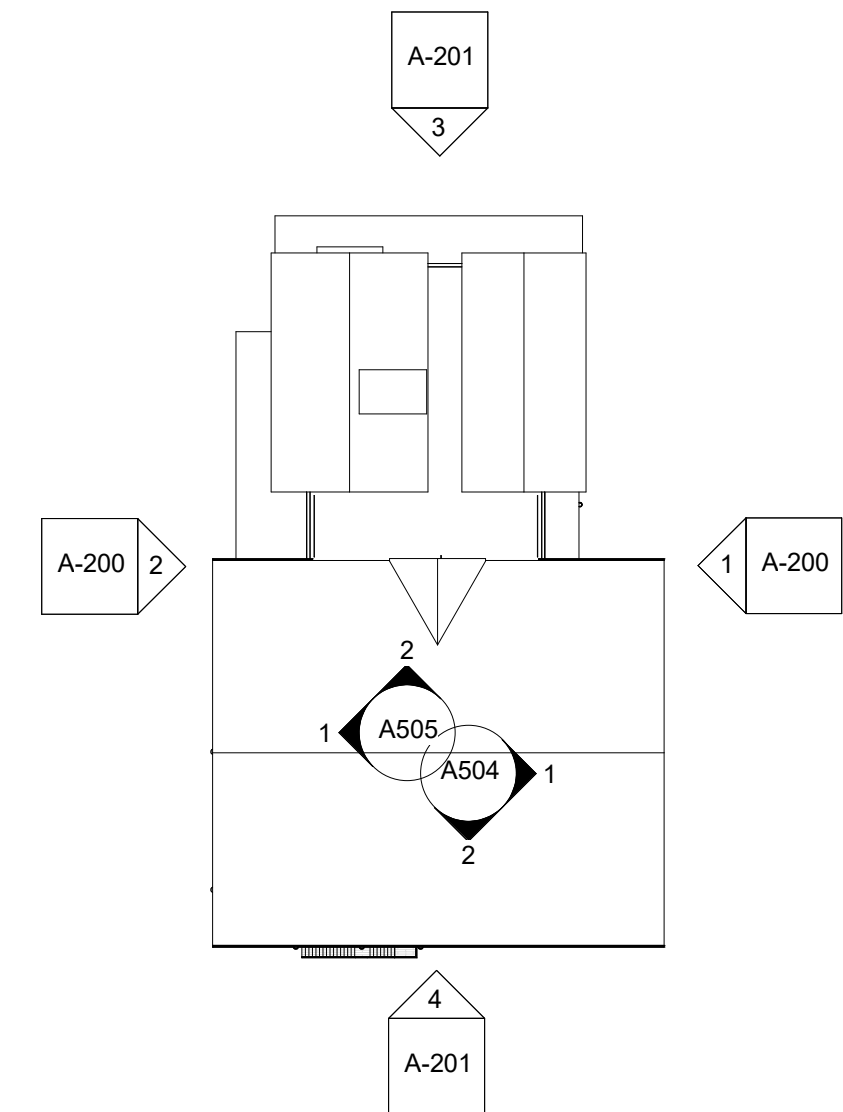

KEY PLAN

1" = 50'-0"

ELEVATION NOTES	
Key Value	Keynote Text
1.01	ASPHALT SHINGLE ROOFING
1.02	MASONRY - GROUND FACE BLOCK - 4X8X16
1.03A	SIDING TYPE 1 - FIBER CEMENT LAP SIDING, 4" EXPOSURE
1.04A	TRIM TYPE 1 - VERTICAL TYPICAL CORNER & DOOR/HORIZOND
1.04C	TRIM TYPE 3 - VERTICAL BATTEN (THIN)_
1.04D	TRIM TYPE 4 - HORIZONTAL_