


(PUBLIC - 300' WIDE LIMITED ACCESS HIGHWAY)

CHAIN LINK FENCE

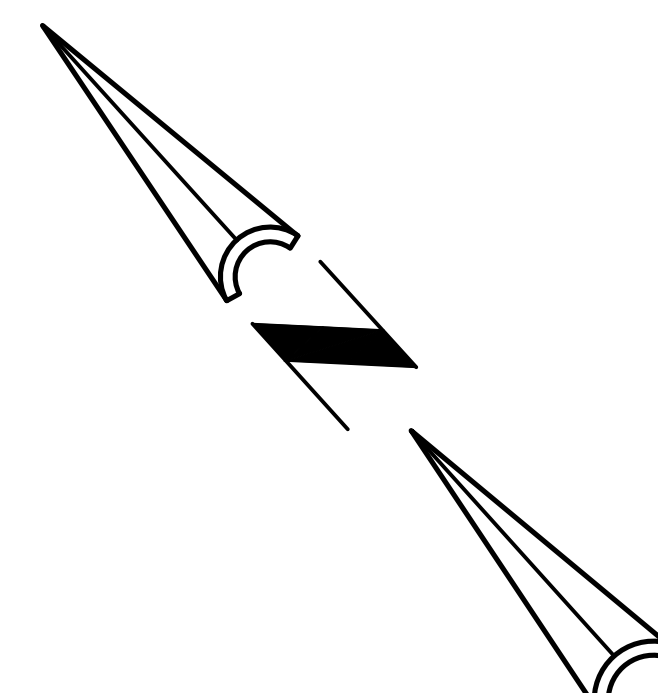

	RIP RAP
	FLARED END SECTION
	CATCH BASIN
	DRAIN MANHOLE
	INSPECTION PORT
W.Q.D.	WATER QUALITY DEVICE
	DRAIN LINE
RD	ROOF DRAIN LINE
	SEWER MANHOLE
SS	SEWER LINE

I CERTIFY THAT THIS PLAN HAS BEEN PREPARED IN CONFORMANCE WITH THE RULES AND REGULATIONS OF THE REGISTERS OF DEEDS OF THE COMMONWEALTH OF MASSACHUSETTS.

SCALE	3	08/31/23	CONSTRUCTION SET	
1"= 30'	2	08/07/23	PEER REVIEW COMMENTS	
DATE	1	07/06/23	PEER REVIEW COMMENTS	
05/24/2023	REV	DATE	REVISION	BY
SHEET 5 of 9	RADER PROPERTIES, INC 33 RIVERSIDE DRIVE PEMBROKE, MASSACHUSETTS SEWER AND DRAINAGE PLAN			
FILE # S003				
JOB # F:\P\2023-026				
DRAWN BY AJV				
CHKD BY BGL				
APPD BY	 KELLY ENGINEERING GROUP civil engineering consultants 0 Campanelli Drive, Braintree, MA 02184 Phone: 781-843-4333 www.kellyengineeringgroup.com			

SHEET NO.

5